



FEATURE LIGHTING SCHEDULE

REF	TYPE	DESCRIPTION	COLOUR	NOTES
FL:01	LED Strip within joinery	Continuous LED strip, refer to dwgs for lengths required Lamp colour: TBC	Square cover frosted	Café banquet seating Underside overhead cupboards Underside of magazine shelves Reception Wall alcove
FL:02	Specialist Pendant lighting - Reception	12 oval shaped polished metal hoops dripping with crystal strands, each hoop suspended inside and above the other. Finally a shower of 90mm diam solid glass balls containing a 12V bi-pin or LED light source completing the illusion of frozen rain. Size TBC		Yellow Goat Design sandra@yellowgoat.com.au +61 7 5532 8659 AU Or similar
FL:03	Specialist Pendant Lighting Retail	Bulb - Warm white spherical compact fluoro globe in-clear sphere with lack cap.		Yellow Goat Design sandra@yellowgoat.com.au +61 7 5532 8659 AU Or similar Refer to plans for numbers and distribution
FL:04	Not in use			

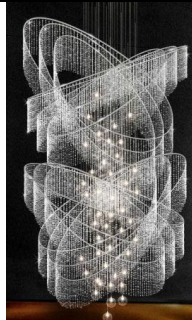





OPERABLE WALL SCHEDULE

REF	TYPE	DESCRIPTION	COLOUR	NOTES
OW:01	'Quik Wall' operable wall system	TBCmm high x 1200mm wide x TBCmm thick acoustic panels to suit width and height of opening, refer to architectural drawings. Provide shop drawings for architects review. Confirm final measurements on site prior to manufacture Rating to be RW 55	Frame – PA:06 Lining – UP:11	Walls in Motion – +63 2 640 7065 or similar Technical data and shop drawing to be provided Fabric lining to have fire retardant foam backing
OW:02	Not used	-	-	-

HYDRAULICS

REF	DESCRIPTION	LOCATION	FINISH	TAPWARE	NOTES
Hand Wash	Wall hung Stainless Steel (SS) Minimum capacity 11 litres (refer local codes & regulations) 445 x 280 x 130 or 11 litre	Café space Refer to drawings	SS	Push button basin pillar tap push action with adjustable timed flow	SS bench and sink by builder Provide tempering valve for warm water Provide paper towel & hand soap dispenser to wall & bin under sink to suit space Refer to typical Stainless Steel Wet Edge Benchtop detail

Project name: UNDP Green One UN House - Hanoi
 Project address: 2E Van Phuc – 304 Kim Ma, Hanoi, Vietnam
 Project no: 63-11049
 Issue date: 14/06/13
 Issue: Execution Design
 Revision: 3
 Pages: ID030

REF	DESCRIPTION	LOCATION	FINISH	TAPWARE	NOTES
Wash Up	1200L bench with rolled & folded SS double bowl sink to be 450L x 500W x 300D minimum bowl dimension With Dish Wash Outlet Bench 1200L x 700D x 900H With Pipe Wall Shelf above to match bench ensure shelf has gap for flexihose	Kitchen area Refer Drawings	SS	Flexi hose down spray with lever action	SS bench and sink by builder Refer to typical Stainless Steel Wet Edge Benchtop detail  dish wash outlet 
Prep Sink	1650 long bench with rolled & folded SS double bowl sink to be 450L x 450W x 300D minimum bowl dimension Pot rails below - 19mm dia. round stainless steel tube, satin polished, 1.2mm thick With Pipe Wall Shelf above to match bench ensure shelf has gap for flexihose	Kitchen area Refer Drawings	SS	Flexi hose down spray with lever action	SS bench and sink by builder Refer to typical Stainless Steel Wet Edge Benchtop detail 
Prep Bench	Rolled & folded SS 450L x 600D x 900H bench With pot rails below - 19mm dia. round stainless steel tube, satin polished, 1.2mm thick	Kitchen area Refer Drawings	SS		
Cleaners sink	Rolled & folded SS 540Wmm x 490Dmm x 600Hmm sink	Kitchen area	SS	TBC	
Prep Sink front of house	Set in prep Stainless Steel sink(SS) 450L x 450W x 300D minimum bowl dimension	Café space Refer to drawings	SS	Push button basin pillar tap push action with adjustable timed flow	SS bench and sink by builder Provide tempering valve for warm water Provide paper towel & hand soap dispenser to wall & bin under sink to suit space Refer to typical Stainless Steel Wet Edge Benchtop detail
Infill Bench	Rolled & folded SS bench size to be confirm on site	Café space Refer to drawings - fryer	SS	-	

Project name: UNDP Green One UN House - Hanoi
 Project address: 2E Van Phuc – 304 Kim Ma, Hanoi, Vietnam
 Project no: 63-11049
 Issue date: 14/06/13
 Issue: Execution Design
 Revision: 3
 Pages: ID031

HYDRAULICS

REF	DESCRIPTION	LOCATION	FINISH	TAPWARE	NOTES
ZIP	Zip Hydro Tap Commercial 4-in-1 compact undersink electric hot water unit BCHD100/125 430271A Model Number: 90680 418mm H x 405mm dia.	Refer drawings	-	Supplied with unit	Ensure that the HWS installation complies with manufacturer's specifications, current codes & standards


SANITARY FIXTURES AND FITTINGS

REF	TYPE	DESCRIPTION	SUPPLIER	FINISH	NOTES
PH	Paper towel dispenser	Stainless steel for interleaved paper		Stainless Steel	Builder to provide sample for architects review, prior to order
TH	Tissue Holder	TOTO TS116W	TOTO	Stainless Steel	Builder to provide sample for architects review, prior to order
LSD	Liquid Soap Dispenser	Recessed stainless steel	-	Stainless Steel	Builder to provide sample for architects review, prior to order



EQUIPMENT: client to confirm all selections

REF	TYPE	SIZE WxHxD mm	SUGGESTED SUPPLIER / SPECIFICATION	GENERIC DESCRIPTION	WATER	POWER - dedicated
EQ:01	TV	60 inch display diagonally	Samsung LED TV Series 8 60" (UA60D8000) Ultra Slim Wall Mount WMN2000CX	LED television screen plus wall mounting kit	-	10Amp
EQ:02	Bar Fridge	525(w) x 819(h) x 570mm(d)	Fisher & Paykel Bar fridge P120RX EZKleen Stainless Steel 115L	115 litres Integrated - Interchangeable doors (with kit) Adjustable Plastic shelves, Ice cube trays, Interior Light, Push button defrost	-	10Amp
EQ:03	Microwave	523(w) x 297(h) x 415mm(d)	Samsung Microwave MW8123ST 34L 1000W Stainless Steel	32 litre microwave, stainless steel	-	10Amp
EQ:04	Dishwasher	600(w) x 850(h) x 600mm(d)	Fisher & Paykel Dishwasher OneTouch™ DW60DOX1 Brushed Stainless Steel 14 piece place setting	60cm freestanding dishwasher, stainless steel	Cold	5 star Wels rated or better, equal in Lotus rating
EQ:05	Toaster Oven	490(w) x 350(h) x 255mm(d)	DeLonghi Benchtop oven EO2079	Fan-assisted convection oven technology for quick and even heating, Multifunctional - bakes, roasts, grills, toasts and reheats, Stainless steel housing, Minimum 17 litre capacity, Non-stick interior and removable crumb tray for easy cleaning, 60-minute timer with auto-off, The fan-assisted convection oven circulates air through a series of lower and upper vents to ensure a constant heating temperature within the oven	-	10Amps
EQ:06	Projector Screen (ceiling mounted)	TCB - size to suit room requirements	ScreenTechnics ElectriCinema Premium Motorised Screen with screen lowering device with trapdoor	Motorised projection screen, recessed in ceiling	-	TBC
EQ:07	Not in Use				-	-
EQ:08	Not in Use					
EQ:09	Not in Use					TBC
EQ:10	Cafe Point of Sale (POS)	TCB	Panasonic Electronic Point Of Sale systems	Cash register system, touch screen	-	TBC

Project name: UNDP Green One UN House - Hanoi
 Project address: 2E Van Phuc – 304 Kim Ma, Hanoi, Vietnam
 Project no: 63-11049
 Issue date: 14/06/13
 Issue: Execution Design
 Revision: 3
 Pages: ID032




EQUIPMENT: client to confirm all selections						
REF	TYPE	SIZE WxHxD mm	SUGGESTED SUPPLIER / SPECIFICATION	GENERIC DESCRIPTION	WATER	POWER - dedicated
EQ:11	Whiteboard - electrical	TBC	Panasonic Business Panaboard range	Meeting spaces Refer to drawings	-	TBC
EQ:12	Cash Teller Recycle machine	TBC	By banking client	By Banking client	-	TBC
EQ:13	ATM	TBC	By client	By Banking client	-	TBC
EQ:14	Photocopiers	TBC	By client	By Copy centre client Each floor By Client	-	TBC
EQ:15	Printer	TBC Client to confirm numbers	By client	Reception Desk Each floor By Client	-	TBC
EQ:16	Bin	To suit drawer dimensions	Hafele 2 x 35L Waste bin for mounting behind drawer front, with soft-close function. For a 450 carcass width. Cat. No. 502.73.922	Integrated double bin drawer pull out	-	-
EQ:17	Fridge	790(w) x 1695(h) x 734mm(d)	Fisher & Paykel ActiveSmart™ Refrigerator-Bottom Freezer E522BLX (left hand) and E522BRX (right hand) EZEKleen Stainless Steel 519L each	Vertical Refrigerator 451-520 Litre Electronic temperature controls for freezer, FrostFree MultiAirflow system, Antibacterial coating on cavity walls, QuickFreezer compartment, safety glass non-spill shelves; 3 height-adjustable, Adjustable door storage shelves with extra-deep base shelf, Bright interior fridge illumination, Reversible door hinging	-	4 Star energy rating in the Lotus system
EQ:18	Baby change table	870(w) x 390mm(h)	JD MacDonald model BCP-JDM.	Surface mounted baby change station. High density polyethylene body (HDPE). JD MacDonald model BCP-JDM.	-	-
EQ:19	Not in Use	-	-	-	-	-
EQ:20	Not in Use	-	-	-	-	-
EQ:21	Pass-through Dishwasher	758(w) x 1510-1995(h) x 815mm(d)	Hobart Hood type dish / glass washer AM900	1000 large plates per hour Low water consumption, Powerful rinse booster elements, of less than 3 litres per cycle, Two minute cycle, auto-starts on door closure, easy-tilt rack slide and removable wash and rinse arm end plugs, Anti-drip door channels 	fresh water connection	Three phase power 25 Amp, minimum 40mm gravity drain

Project name: UNDP Green One UN House - Hanoi
 Project address: 2E Van Phuc – 304 Kim Ma, Hanoi, Vietnam
 Project no: 63-11049
 Issue date: 14/06/13
 Issue: Execution Design
 Revision: 3
 Pages: ID033




EQUIPMENT: client to confirm all selections						
REF	TYPE	SIZE WxHxD mm	SUGGESTED SUPPLIER / SPECIFICATION	GENERIC DESCRIPTION	WATER	POWER - dedicated
EQ:22	Rack Trolley	Client to confirm 643(w) x 1650(h) x 635mm(d)	Hupfer Basket Transfer Trolley KTW 1/10	Stainless Steel, Rack trolley 10 crockery baskets 	-	-
EQ:23	Cool Room + Freezer Room	Client to confirm 3850(l) x TBC on site (h) x 2400mm(w)	Local Kitchen Equipment Contractor / Manufacturer	Refrigerated Cool Room c/w heavy duty sliding, capable of cooling 150-200 kgs of pre packed meals entering at 7 deg C down to 2 deg C within 24 hours, Refrigerant is to be type R507 ozone friendly, digital L.E.D. controller to the room, controller will be capable of controlling temperature, defrost and audio-visual alarm, fit waterproof fluoro lighting with waterproof light switch to the inside of the room with red neon indicator to external of room, All fittings are to be wired by the KEC to a junction box for final connection by others. KEC is to allow for electrical wiring between the remote condenser and room, plastic mat shelving with Microban protection and Atlas frames	-	15 Amp, min 50 diameter Tundish
EQ:24	Clean Cabinet	600(w) x 500(d) x 2100mm(h)	Locally sourced	Lockable Double casing construction with noise insulation in doors. Chromed handles, stainless steel hinges and door magnet. Stainless steel shelves, adjustment interval 25 mm. Floor cupboard with 4 shelves on one side and open space to other for mop bucket 	-	-

Project name: UNDP Green One UN House - Hanoi
 Project address: 2E Van Phuc – 304 Kim Ma, Hanoi, Vietnam
 Project no: 63-11049
 Issue date: 14/06/13
 Issue: Execution Design
 Revision: 3
 Pages: ID034

EQUIPMENT: client to confirm all selections





REF	TYPE	SIZE WxHxD mm	SUGGESTED SUPPLIER / SPECIFICATION	GENERIC DESCRIPTION	WATER	POWER - dedicated
EQ:25	Deep Fryer	400(w) max. x 1100(h) x 820mm(d)	LUUS FG-40 Single pan twin baskets	<p>Single pan twin baskets, with Infrared high efficiency heating elements - fast oil recovery rates, Stainless steel tank with 22 litre oil capacity, Large 'cool zone' to help trap food particles and prolong oil life, External thermostat control for ease of use</p> <p>Over temperature safety cut-off, baskets, drain valve and overnight lid, Sturdy steel frame construction for longer lasting durability, Complete stainless steel exterior including side panels, Height adjustable feet</p> 	-	15Amp
EQ:26	4 Burner Oven +grill	900(w) max x 1100(h) x 820mm(d)	LUUS CRO-4B3P 4 burners plus 300 grill and oven	<p>4 Burner + Oven on Legs w/Midshelf, Dual Heating Controls, Drip Tray and Adjustable Feet, Stainless Steel Finish, heavy duty range with natural convection oven.</p> 	-	Gas
EQ:27	Griddle	300(w) max x 1100(h) x 800mm(d)	LUUS BCH-3P-B 300 Grill Benchttop plus legs, undershelf and side shields		-	Gas

Project name: UNDP Green One UN House - Hanoi
 Project address: 2E Van Phuc – 304 Kim Ma, Hanoi, Vietnam
 Project no: 63-11049
 Issue date: 14/06/13
 Issue: Execution Design
 Revision: 3
 Pages: ID035



EQUIPMENT: client to confirm all selections						
REF	TYPE	SIZE WxHxD mm	SUGGESTED SUPPLIER / SPECIFICATION	GENERIC DESCRIPTION	WATER	POWER - dedicated
EQ:28	Wok Range	1830(w)x 1200 (h) x 845mm(d)	LUUS WF-2C2B 2 chimney burners plus 2 open burners	One piece all welded stainless steel, Water cooled cook top with water swivel spout with extendable arm, Wok holes-cast iron in 330 or 405 mm diameter, individually operated wok burners 	Fresh water connection	Gas 260 Mj
EQ:29	Kettle	800(w) x 850(d) x 700mm(h)	Optima 850 Electric Quick Boiling Kettle 1 - 125L capacity model no. 2022831 OR Cleveland Steam Jacketed Electric Kettles Table top KET-12-T 45L capacity	Electric Quick Boiling Kettle Inside kettle made completely of extremely corrosion-resistant, fast heating up Time and low energy consumption 3 cooking programmes as standard (light simmering, medium, simmering and strong boiling) Thermostatic or electronic temperature regulation Below kettle provide a stainless steel slide out pouring drawer in channel runners to support containers when filling, and to direct discharge of the kettle over a floor gutter at other times 	fresh water connection	3 Phase; 12 KW – discharge Pipe the waste to discharge over a tundish
EQ:30	2 door Under bench Fridge	1600(w) x 825(h) x 700mm(d)	Skope CL400 2 Door Chiller 390L	400 Litres Self closing double glazed toughened safety glass doors with silver aluminium frames, integrated motor to left hand side of unit, stainless steel surround on stainless steel adjustable legs, 5 adjustable plastic coated shelves operating temperatures adjustment from +10C to + 40C in 430C ambient, consistent temperatures maintained by fan-force ducted air flow, hot air to blow up glass – reducing condensation to ensure product visible within cabinet 	-	10 Amp, no discharge

Project name: UNDP Green One UN House - Hanoi
 Project address: 2E Van Phuc – 304 Kim Ma, Hanoi, Vietnam
 Project no: 63-11049
 Issue date: 14/06/13
 Issue: Execution Design
 Revision: 3
 Pages: ID036

EQUIPMENT: client to confirm all selections




REF	TYPE	SIZE WxHxD mm	SUGGESTED SUPPLIER / SPECIFICATION	GENERIC DESCRIPTION	WATER	POWER - dedicated
EQ:31	Rice Cooker	507(w) x 465(h) x 493mm(d)	Winco GRC-10L Automatic commercial natural gas rice cooker 100 cup	100 cups, stainless steel cooker 	-	Gas
EQ:31A	Rice Warmer	427(w) x 445(h) x 427mm(d)	Winco RW-S450 100 cup Electric Rice Warmer	100 cups, stainless steel 	-	120V/84W
EQ:32	Salamander	900(w) x 460(h) x 450mm(d)	Waldorf 800 Series Electric Salamander SN8200E	Overall Construction - Stainless steel, under grilling area with grease trough, Two 3kW infra-red elements Racking - Four position racking, Adjustable chrome wire rack with heat resistant handles Controls - Large easy use controls, Heat resistant reinforced control knobs, Indicator light for each element on, Recessed front panels for hand and control protection, Each side controlled by a 3 heat switch, Stainless steel and vitreous porcelain enamel surfaces used throughout 		Electrical 6kW ; 25Amps
EQ:33	Salad Preparation Fridge	1200(w) x 1050(h) x 700mm(d)	Skope BC120 2 Door Sandwich Counter Chiller 275L	4- 8 pans set into top with blow chill air over pots, self closing doors, integrated motor to left hand side of unit, stainless steel surround on stainless steel adjustable legs, 5 adjustable plastic coated shelves operating temperatures adjustment from +10C to + 40C in 430C ambient, consistent temperatures maintained by fan-force ducted air flow, hot air to blow up glass – reducing condensation to ensure product visible within cabinet 		10 Amps

Project name: UNDP Green One UN House - Hanoi
 Project address: 2E Van Phuc – 304 Kim Ma, Hanoi, Vietnam
 Project no: 63-11049
 Issue date: 14/06/13
 Issue: Execution Design
 Revision: 3
 Pages: ID037


EQUIPMENT: client to confirm all selections						
REF	TYPE	SIZE WxHxD mm	SUGGESTED SUPPLIER / SPECIFICATION	GENERIC DESCRIPTION	WATER	POWER - dedicated
EQ:34	Mobile insulated transport boxes	780(w) x 490(d) x 1495mm(h)	Electrolux Banqueting trolley	Watertight inner body, stainless steel, Moisture regulation, Collecting channel for condensation water, hot-air circulation, rugged synthetic castors, No dirt catching joints, temperature 20 °C to +100 °C, 20 pair of deep-drawn, support ledges for the insertion of GN containers 		15 Amps
EQ:35	Combi Oven	Client to confirm - varies 900(w) x 1050(h) x 890mm(d)	Hobart Combi Oven 202	40 Tray Electric Combi Oven General requirements - 5 Cooking Modes and Low Temperature Cooking, Humidity Control with Core Probe Boiler Unit , Integrated Automatic Wash System 4 Fan Speed - Auto-Reverse Fan, HACCP Compatability Filter Connection Kit Included, Touch/Manual Control Panel. Snap On/Off Door Seal, External Oven Lights External Core Temperature Probe, Self - Integrated Door Drip Tray, Auto Reverse Fan with Patent Breaking System Double Glazed Door & Insulated Panels, Smooth, High Quality & Robust Stainless Steel 	Cold water	15 Amps
EQ:36A	Coffee Grinder	220(w) x 385(d) x 575(h) mm	Rancilio, Kryo 65	brass grinding chamber, continuous micrometric adjustment with anti-accidental rotation lock,	-	10 Amp Available in 110V - 230V - 400 3V
EQ:36	Coffee Machine	990(w) x 495(d) x 520(h)	Rancilio, Classe 7S	3 group, semiautomatic control, automatic water level control,	filtered cold water	20 Amp, no discharge

Project name: UNDP Green One UN House - Hanoi
 Project address: 2E Van Phuc – 304 Kim Ma, Hanoi, Vietnam
 Project no: 63-11049
 Issue date: 14/06/13
 Issue: Execution Design
 Revision: 3
 Pages: ID038

EQUIPMENT: client to confirm all selections


REF	TYPE	SIZE WxHxD mm	SUGGESTED SUPPLIER / SPECIFICATION	GENERIC DESCRIPTION	WATER	POWER - dedicated
EQ:37	Commercial Kitchen Microwave	Client to confirm	Hobart NE1856 Compact Heavy Duty Microwave Oven	1800W , Stainless steel cabinet and cavity , 3 power levels (Defrost 340W, Medium 900W, High 1800W) , 2 and 3-stage cooking, Tone control (On/Off), Grab and Go see through door, Digital display, Self-diagnostics, Easy-to-clean air filter (with reminder) Removable ceiling splatter shield, will fit 150mm tall steam table pan with cover 	-	15 Amps
EQ:38	Contact Press	415(w) x 240(h) x 550mm(d)	Woodson WCT6 Contact Toaster 4/6 Slice	4-6 Slice Bottom heat plates with spring balance top platen with seal, drain groove, full stainless steel body and lift mechanism to have heavy duty long life construction, thermostat control and light indicator , Non slip feet 4 	-	10 Amps
EQ:39	Drinks display	900(w) x 2125(h) x 820mm(d)	Bromic Jordao OD0900FP Open Front Plus 90	Refrigerated wall-case system, designed with a optimize the cleaning system, Displayed foodstuffs are always kept at the right temperature by chilled airflow secured through a well-dimensioned refrigerating installation. A low power consumption and low environmental impact - tank to be built without the use of CFC. 	-	230V / 1 / 50Hz
EQ:40	Salad Display	1680(w) x 750 (h) x 615mm(d)	Roband SR25RD Square glass refrigerated display bar, built in to benchtop	Glass food display bar showcase, Made of Stainless Steel Tempered glass with heater wire Low noise level Food Ambient Food	-	240V 10amps

Project name: UNDP Green One UN House - Hanoi
 Project address: 2E Van Phuc – 304 Kim Ma, Hanoi, Vietnam
 Project no: 63-11049
 Issue date: 14/06/13
 Issue: Execution Design
 Revision: 3
 Pages: ID039

EQUIPMENT: client to confirm all selections						
REF	TYPE	SIZE WxHxD mm	SUGGESTED SUPPLIER / SPECIFICATION	GENERIC DESCRIPTION	WATER	POWER - dedicated
EQ:41	Sandwich display	1500(w) x 1305(h) x 662mm(d) 900(w) x 1305(h) x 662mm(d)	Skope FDM1200 Chiller Display FDM900 Ambient Display	Consistent temperatures maintained by fan forced ducted air flow, Removable sliding doors, door track, shelves, trays and covered internal corners for easy cleaning, Two self-closing double glazed sliding doors with internal mirror finish, Two tilt adjustable shelves, with wire trays 	-	240V 10amps
EQ:42	Bain Marie	Sizes Vary 1355(w) x 750(h) x 615mm(d) 1680(w) x 750(h) x 615mm(d)	Roband S24 S25 Square glass hot food display bar, built in to benchtop	Stainless steel construction in bright annealed finish, 1 Wet or dry operation, 1 Thermostat controls, 1 Welded tank with large 20mm drain cock, 1 Full size gastronorm cavity to take choice of 65mm and 150mm pan combinations, 1 Clear thermometer readout, Non slip feet for counter top models		10Amps 15Amp
EQ:43- EQ:49	Not In Use					
EQ:50	Blender		Santos Blender - 62	The Brushless Blender above counter	-	10Amp
EQ:51	Food Processor		Bt International Hanoi Office: 22 lot 2A, Trung Yen 11 Street, Cau Giay Dist., Ha Noi, Vietnam. Tel: +844 3786 8880 Fax: +844 3786 8840 Email: hn@btcorp.com.vn Hotline: 093 200 8080	RobotCoupe Series D -R301U Combination Continuous Feed, Vegetable Prep and Vertical Cutter Mixer	-	15Amp
EQ:52	Slicer	640(w) x 610 (d) x 510 (h)mm	Bt International Hanoi Office: 22 lot 2A, Trung Yen 11 Street, Cau Giay Dist., Ha Noi, Vietnam. Tel: +844 3786 8880 Fax: +844 3786 8840 Email: hn@btcorp.com.vn Hotline: 093 200 8080	Sirman - Mirra300 Medium Duty Slicer	-	10Amp
EQ:53	Mixer		KitchenAid Heavy Duty	Commercial Series 8-Qt Bowl Lift Stand Mixer, 10 speed , Power knead™ Spiral Dough Hook, Flat Beater, and Stainless Steel Wire Whip	-	10Amp 325 Watts
EQ:54	Glass Trays	500 x 500	No289, D3 St, 25 Ward, Binh Th_nh Dist, Hochiminh City, Vietnam	Tray types – variety will be required dependant on crockery 20 hole basket 36 glass basket 49 glass basket	-	-

Project name: UNDP Green One UN House - Hanoi
 Project address: 2E Van Phuc – 304 Kim Ma, Hanoi, Vietnam
 Project no: 63-11049
 Issue date: 14/06/13
 Issue: Execution Design
 Revision: 3
 Pages: ID040

EQUIPMENT: client to confirm all selections

REF	TYPE	SIZE WxHxD mm	SUGGESTED SUPPLIER / SPECIFICATION	GENERIC DESCRIPTION	WATER	POWER - dedicated
EQ:55	Examination Premium Table	750H X 680W X 1900L		 <p>Premium Examination Table is a fixed height couch that is the perfect examination & treatment table for the discerning medical practitioner & nurse. Featuring premium anti-microbial vinyl & foam specification to provide optimum support and comfort to patients and long term durability.</p>		
EQ:56	A - Privacy track B – Disposable Curtains	Confirm on site To match track	<p>Alltrack Supplies 289 Hancock St, Doubleview WA. Tel: 618 9446 1198 www.alltracks.com.au</p> <p>Endurocide Bio Technics (SIP) Co., Ltd. No.405 Suhong East Road,SIP, Suzhou,China,215026 Tel.: +86(0)512 65916865 Fax: +86(0)512 65916800 Email: moonlord@endurocide.net</p>	<p>Track - Monotrack- moving curtain rail system or equal approved. D9100 Bedscreen/Cubicle tracks, ceiling mounted with associated fixing brackets, curtain swivel hooks, stops etc. required to provide a complete system.</p> <p>Endurocide hospital disposable cubicle curtains -coated with polysiloxane that has been impregnated with an antimicrobial, forms a protective barrier (kills bacteria, assisting in minimising hospital acquired infections)</p>		
EQ:57	Not in use					
EQ:58	Not in use					

JOINERY HARDWARE SCHEDULE

REF	TYPE	DESCRIPTION	COLOUR	NOTES
JH:01	Door handle	Continuous aluminium profile, 16 x 2500mm Hafele Cat No 126.27.914. Or equal approved.	Silver anodised	Refer joinery. Handles to be continuous to full length of door. Provide sample for architect review.
JH:02	Wardrobe rail	Wardrobe rail, 30 x 15 x 3600mm Hafele Cat No 801.08.703. Or equal approved.	White powdercoated	Refer joinery. Rails cut to be cut to length. Provide sample for architect review.
JH:03	Coat Hooks	Wardrobe hook. Hafele Cat No. 842.40.950. Or equal approved.	Steel, aluminium coloured.	Provide 10 coat hooks, equally spaced, to Prayer/Meditation room. Refer joinery JO:05. Provide sample for architect review.
JH:04	Cable Entry Cap	60mm dia. Plastic cable entry cap. Or equal approved. Hafele Cat No 631.11.702 (white) Hafele Cat No 631.11.312 (charcoal)	white and charcoal	White entry caps to be used with laminates LM:01 Charcoal entry caps to be used with laminates LM:02, LM:03 LM:04 and timber finishes. Provide sample for architect review.

Project name: UNDP Green One UN House - Hanoi
 Project address: 2E Van Phuc – 304 Kim Ma, Hanoi, Vietnam
 Project no: 63-11049
 Issue date: 14/06/13
 Issue: Execution Design
 Revision: 3
 Pages: ID041


JOINERY HARDWARE SCHEDULE

REF	TYPE	DESCRIPTION	COLOUR	NOTES
JH:05	Ventilation Grill	Ventilation grill aluminium 400w x 86h. Or equal approved. Hafele Cat No 575.23.627 (white)	white	Refer joinery. Provide sample for architect review.
JH:06	Ventilation Grill	Ventilation grill aluminium 400w x 86h. Or equal approved. Hafele Cat No 575.23.921 (silver)	silver	Refer joinery. Provide sample for architect review.
JH:07	Waste Bin	Waste bin for mounting behind fronts, with soft close function. 2 x 35 litre capacity bins. Hafele Cat No 502.73.922 Or equal approved.	Light grey	Bins require a cabinet width of 450mm. Joiner to coordinate. Provide sample for architect review.
JH08	Cutlery Tray	Plastic cutlery tray insert. Max size 499w x 496d x 50h Hafele Cat No 556.60.770 Or equal approved.	White	Tray requires a carcass width of 500 - 550mm. The tray type may need to be altered to suit the final drawer dimensions. Trim tray edge/border to suit drawer dimension. Joiner to coordinate and arrange samples.

ACCESSORIES SCHEDULE

REF	TYPE	DESCRIPTION	COLOUR	NOTES
AC:01	Privacy Curtain + Track	Alltrack Supplies "Monotrack" moving curtain rail system, or equal approved. D9100 Bedscreen/Cubicle track, ceiling mounted with associated fixing brackets, curtain swivel hooks, stops etc required to provide a complete system. Alltrack Supplies, or equal approved, privacy screen fabric. Design – Waffle, colour – Mink. Curtain drop approx. 2600mm (confirm dimension on site). Allow curtain to stop 100mm afl.	White track + components	Alltrack Supplies 289 Hancock St, Doubleview WA. Tel: 618 9446 1198 www.alltracks.com.au

Project name: UNDP Green One UN House - Hanoi
 Project address: 2E Van Phuc – 304 Kim Ma, Hanoi, Vietnam
 Project no: 63-11049
 Issue date: 14/06/13
 Issue: Execution Design
 Revision: 3
 Pages: ID042

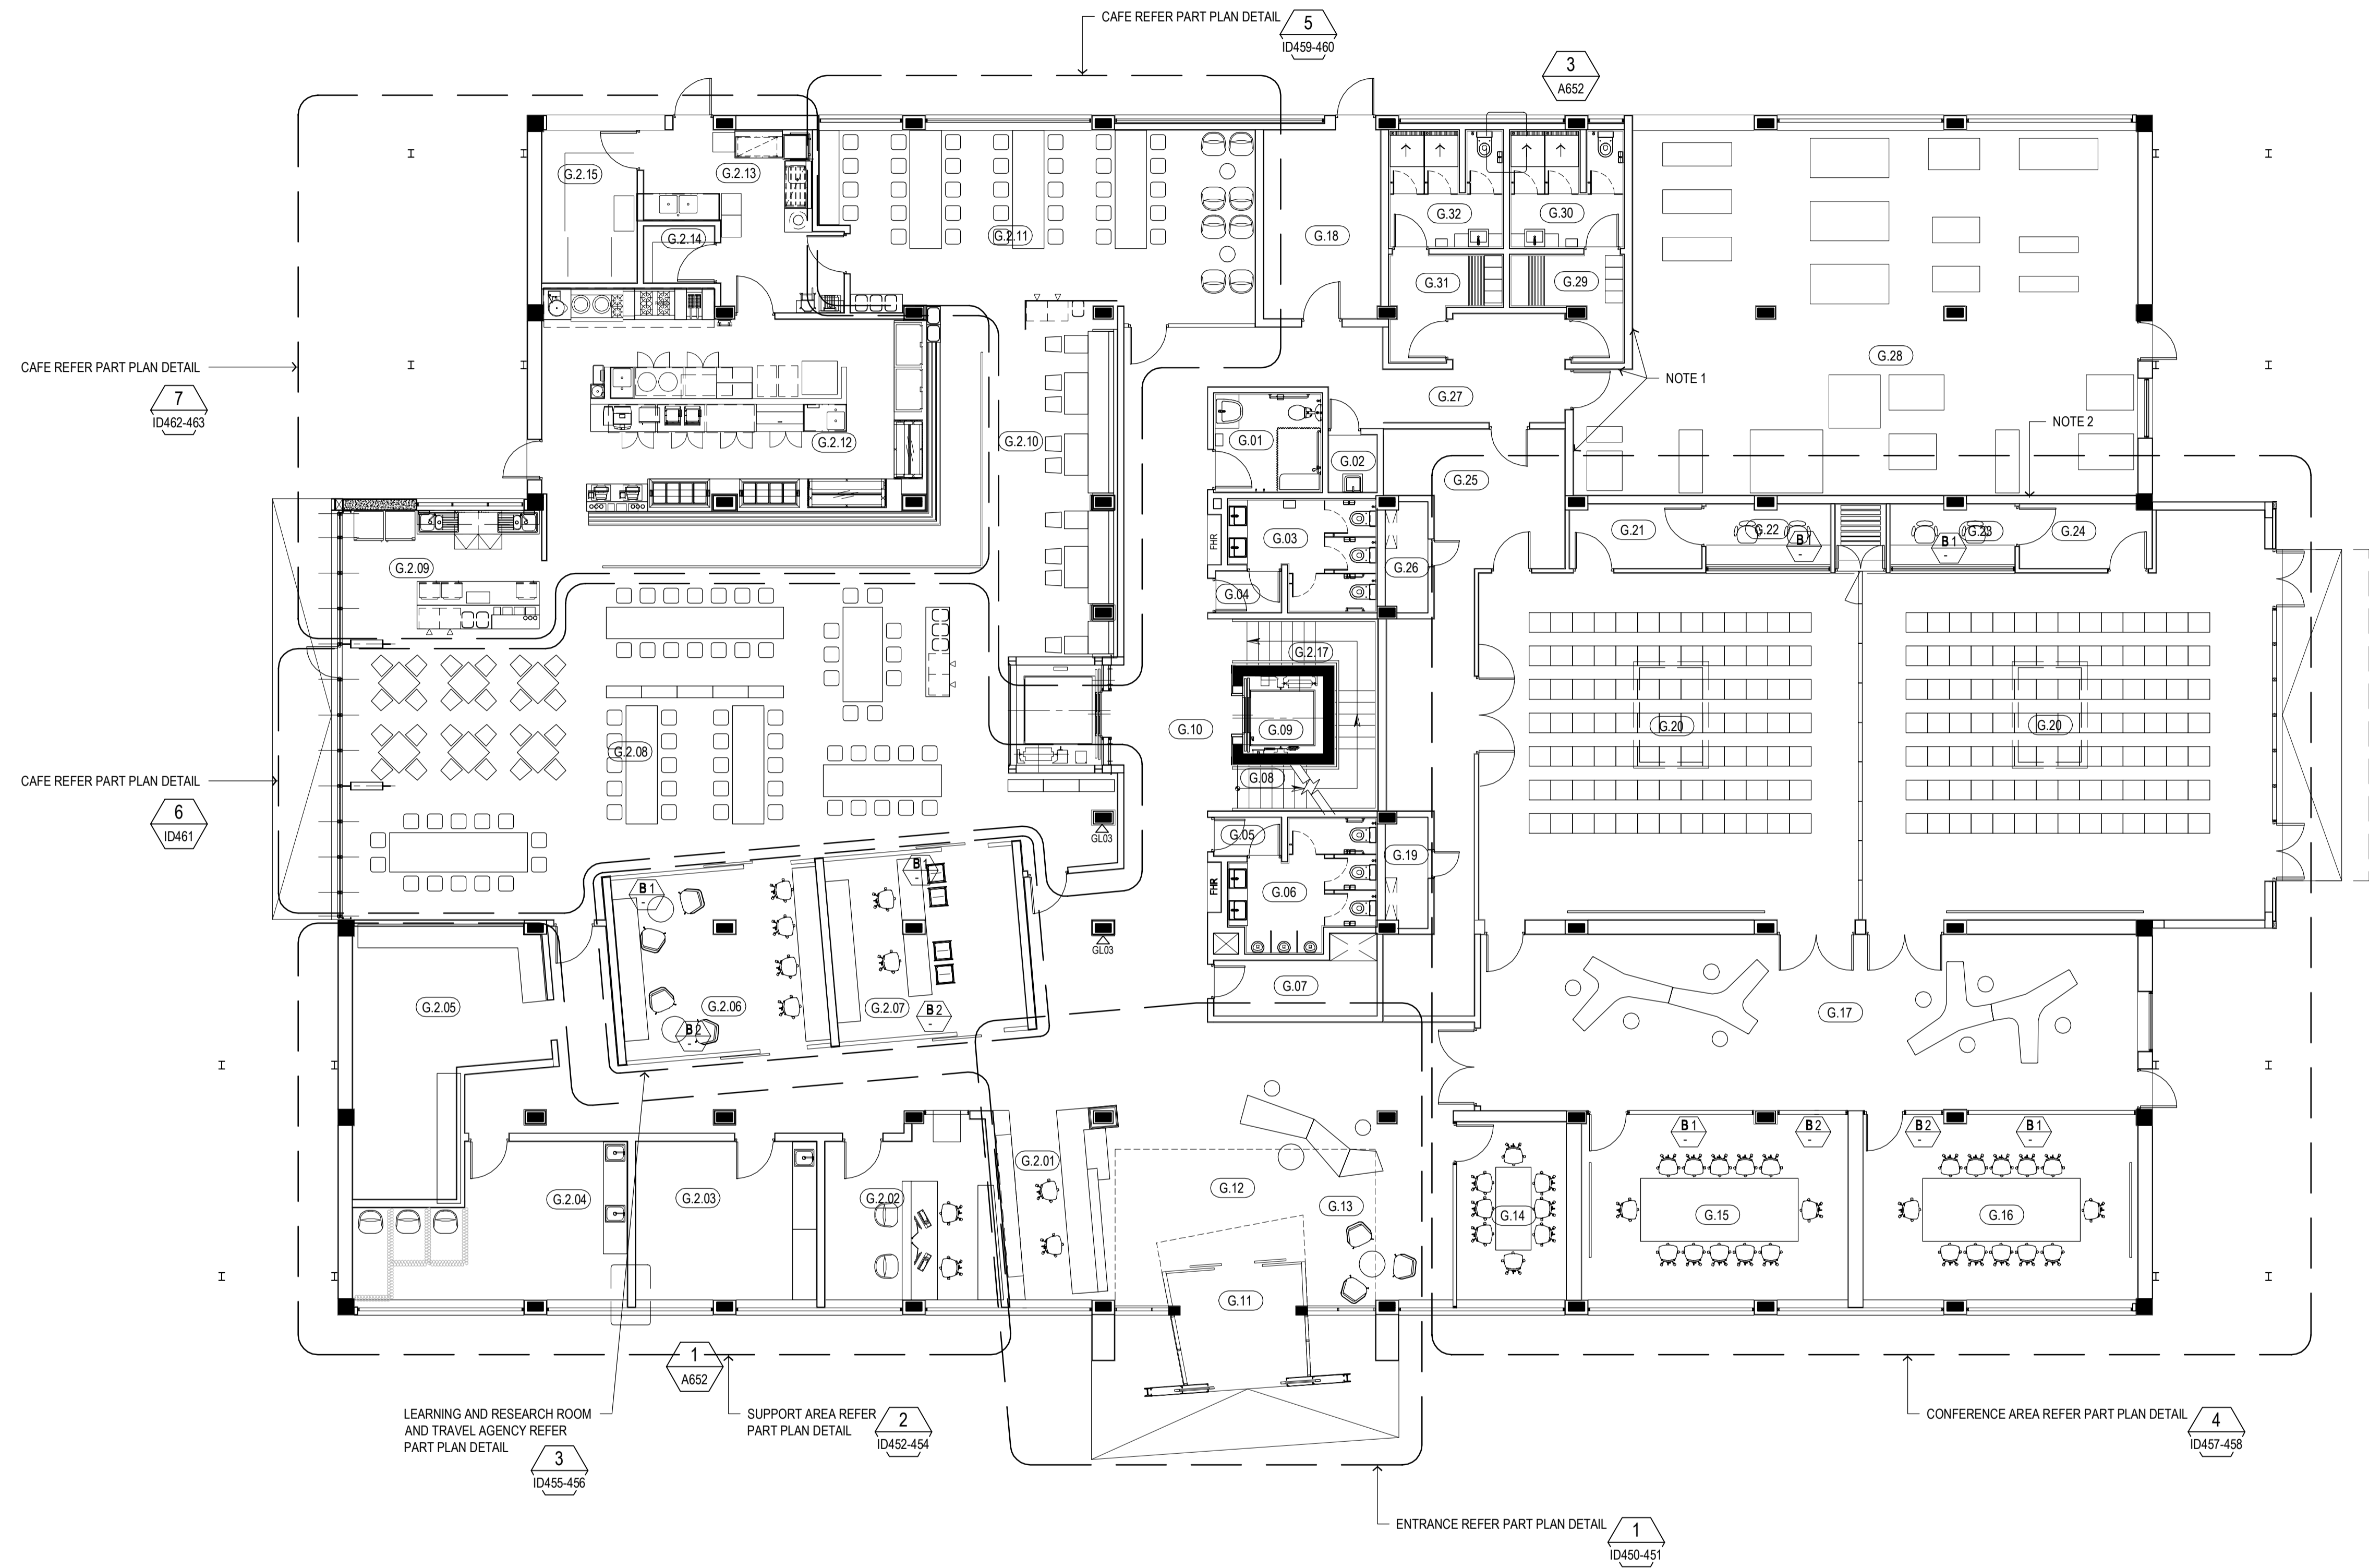

NOTE 1: PINBOARD (L1:02) FLOOR TO CEILING APPLIED TO WALLS

NOTE 2: MIRROR (GL:06) FLOOR TO CEILING. JOINTS EQUALLY SPACED, MAX 1200 WIDE PANELS

GROUND FLOOR KEY PLAN
SCALE 1:100

HỒ SƠ THIẾT KẾ BẢN VẼ THI CÔNG -EXECUTION DESIGN

A	EXECUTION DESIGN	LB	THA	21/10/11		
B	ED FINAL ISSUE	LB	THA	05/12/11		
No	Revision	Note: * indicates signatures on original issue of drawing or last revision of drawing	Drawn	Checked	Approved	Date

GHD CLIENTS | PEOPLE | PERFORMANCE

11/F Alphaland Southgate Tower 2258 Chino Roces Ave corner EDSA
Makati City 1232 Philippines
T 63 2 479 5600 F 63 2 479 5601
E mnlmail@ghd.com W www.ghd.com

GIÁM ĐỐC GHD VIỆT NAM

(Signature)

TOBY GARAFILLIS

Project Director	CHRIS LLOYD	Chief Design Architect	ANDREW RASZEWSKI
Project Architect	BRENDAN SHEEDY	Reviewer	TRAN HAI ANH
Drawn	LISA BOOKER		
Date	05/12/11		
Scale	1:100		

Client: **LIÊN HỢP QUỐC - UNITED NATIONS DEVELOPMENT PROGRAM - UNDP**


Project: **DỰ ÁN TÒA NHÀ CHUNG LIÊN HỢP QUỐC (2E VẠN PHÚC - 304 KIM MÃ)**

Title: **MẶT BẰNG TẦNG TRỆT
GROUND FLOOR KEY PLAN**

Original Size: **A1** Drawing No: **63-11049-ID100**

Rev: **B**

This Drawing must not be used for Construction unless signed as Approved

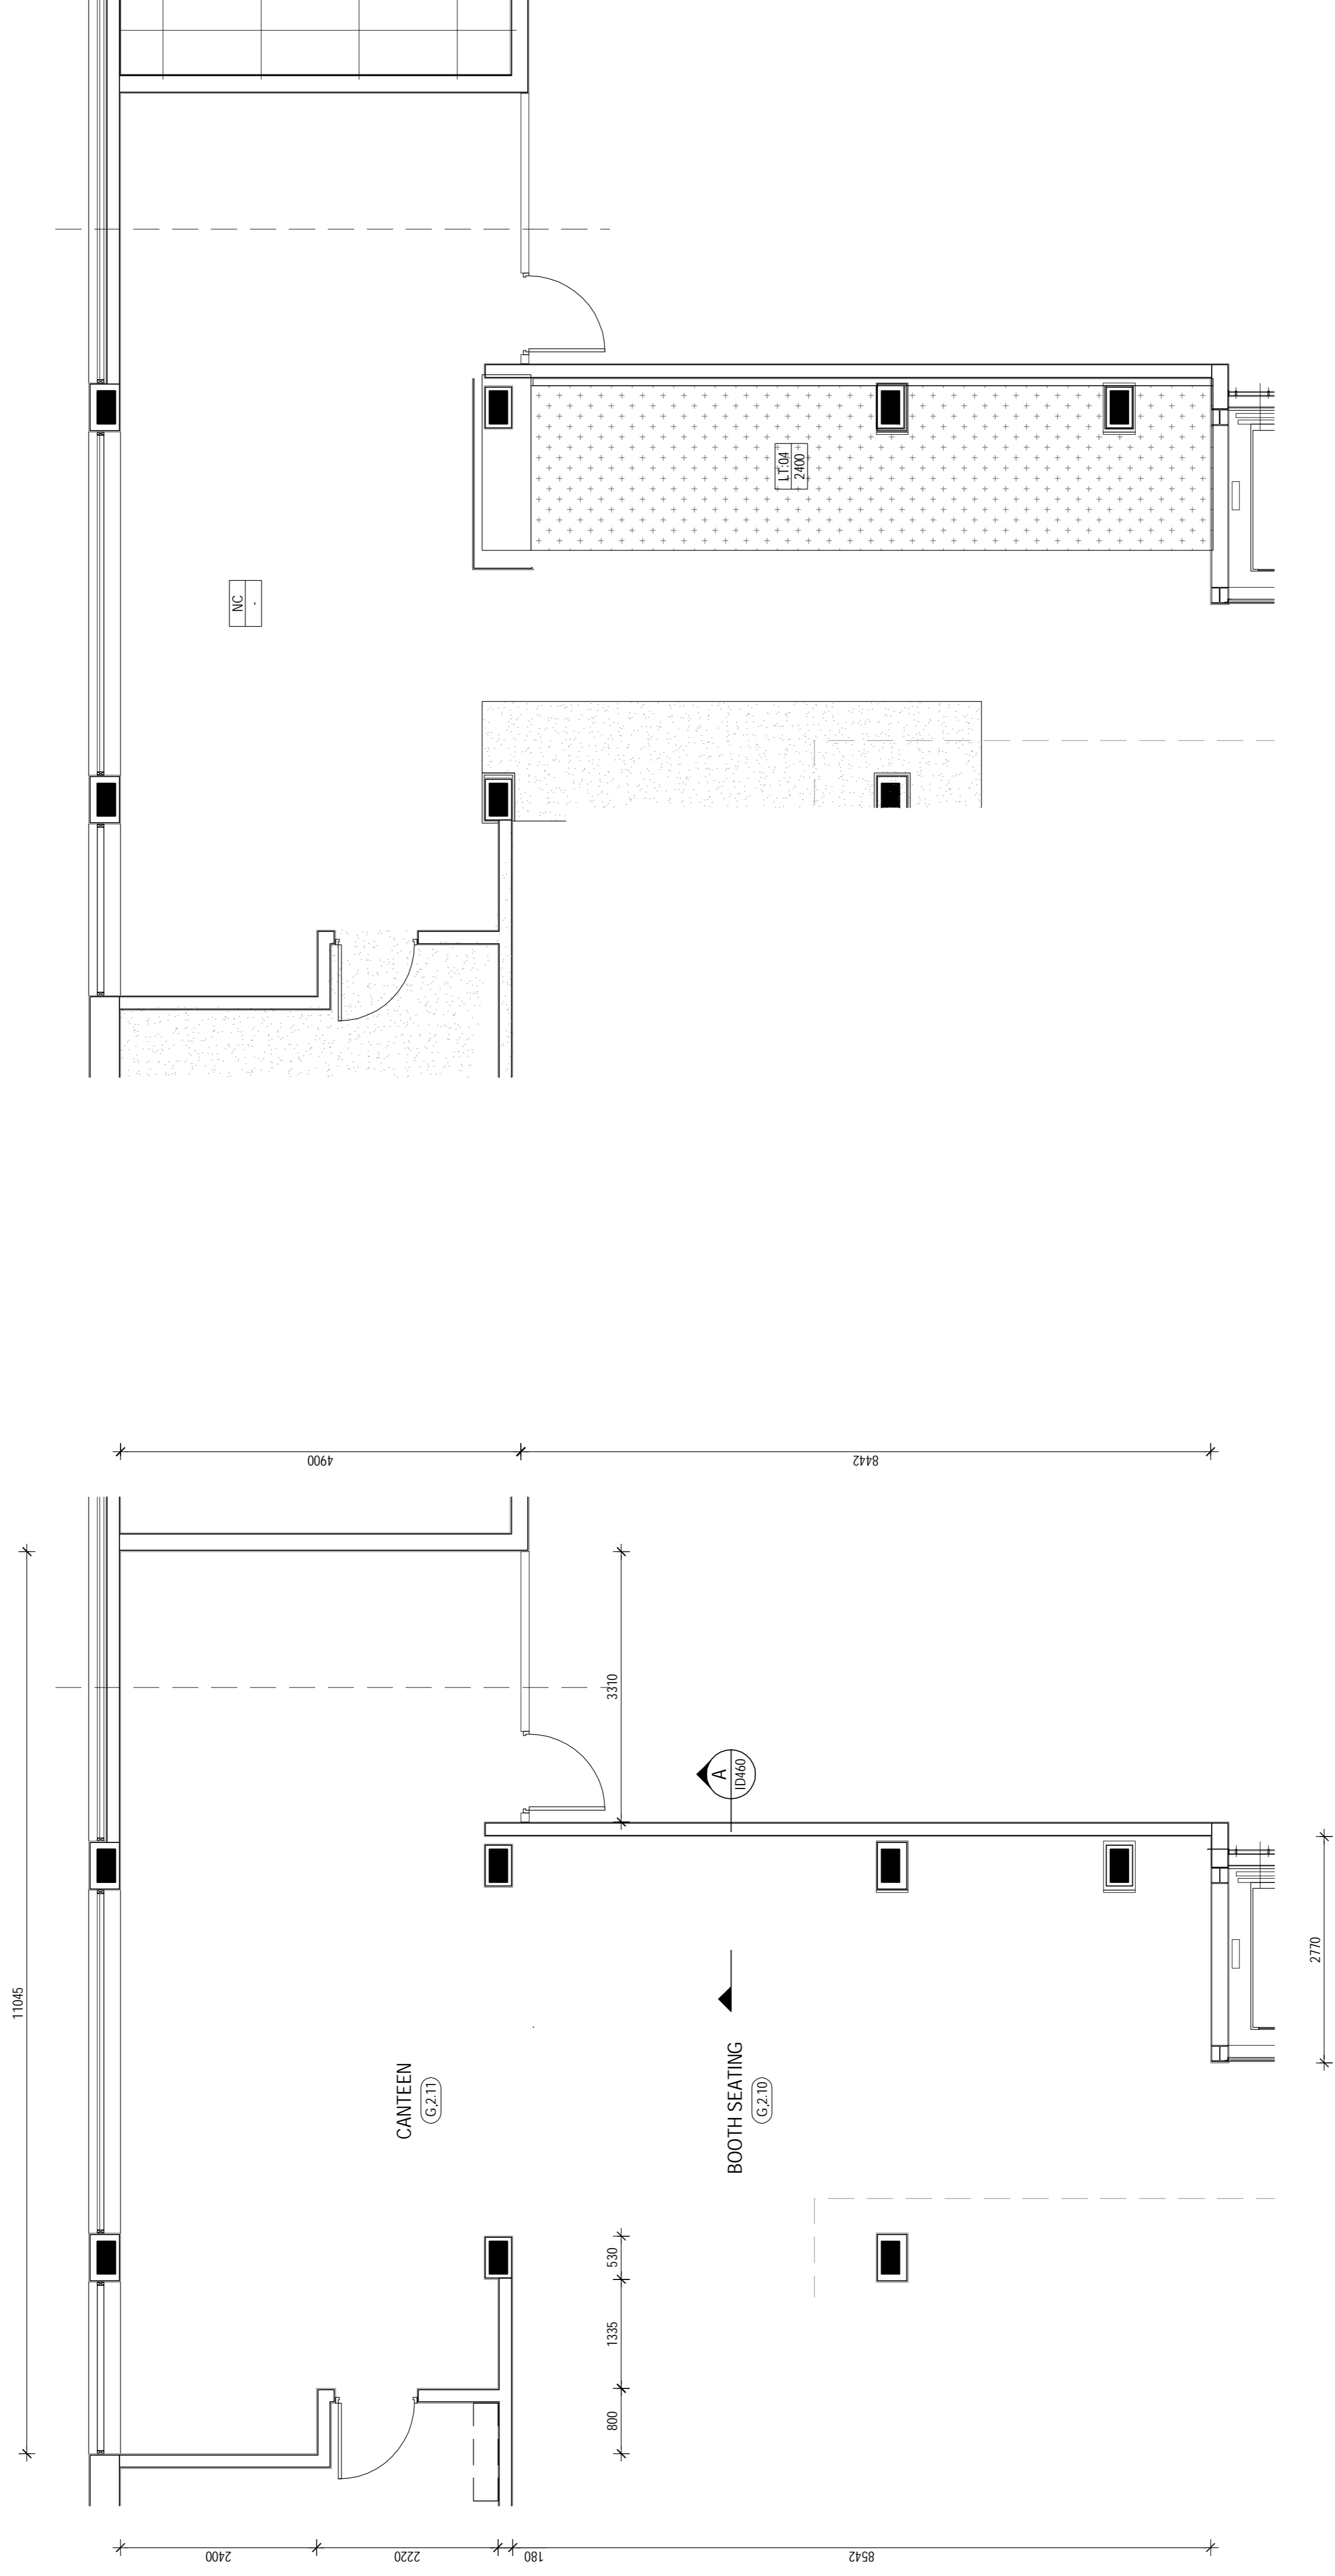


5 CAFE PART PLAN
SCALE 1: 50

REFLECTED CEILING PLAN
SCALE 1:50

A EXECUTION DESIGN		LB	THA	21/10/11	GIAM ĐỐC GHD/VIET NAM		Project Director	CHRIS LLOYD	Chief Design Architect	ANDREW RASZEWSKI	Client	LIÊN HỢP QUỐC - UNITED NATIONS DEVELOPMENT PROGRAM - UNDP				
B ED FINAL ISSUE		LB	THA	05/12/11	GIÁM ĐỐC GHD/VIỆT NAM		Project Architect	BRENDAN SHEEDY	Reviewer	TRAN HAI ANH	Project	DỰ ÁN TÒA NHÀ CHUNG LIÊN HỢP QUỐC (2E VẠN PHÚC - 304 KIM MÃ)				
No	Revision	Note	Drawn	Checked/Approved	Date	TOBY GARAFILIS	Drawn	LISA BOOKER	Scale	1:50	Title	CHI TIẾT 5- PHÒNG CAFE- BÀN 1/2				
											Client/Drawn	CAFE PART PLAN - DETAIL 5 - SHEET 1 OF 2				
<p>This Drawing must not be used for construction unless signed as Approved</p>											Sheet Size	A1	Drawing No:	63-11049-ID459	Rev:	B

GHD CLIENTS | PEOPLE | PERFORMANCE


11/F Alphasand Southgate Tower 2258 Chino Rocas Ave corner EDSA
Makati City 1232 Philippines
T 63 2 479 5600 F 63 2 479 5601
E mmail@ghd.com W www.ghd.com

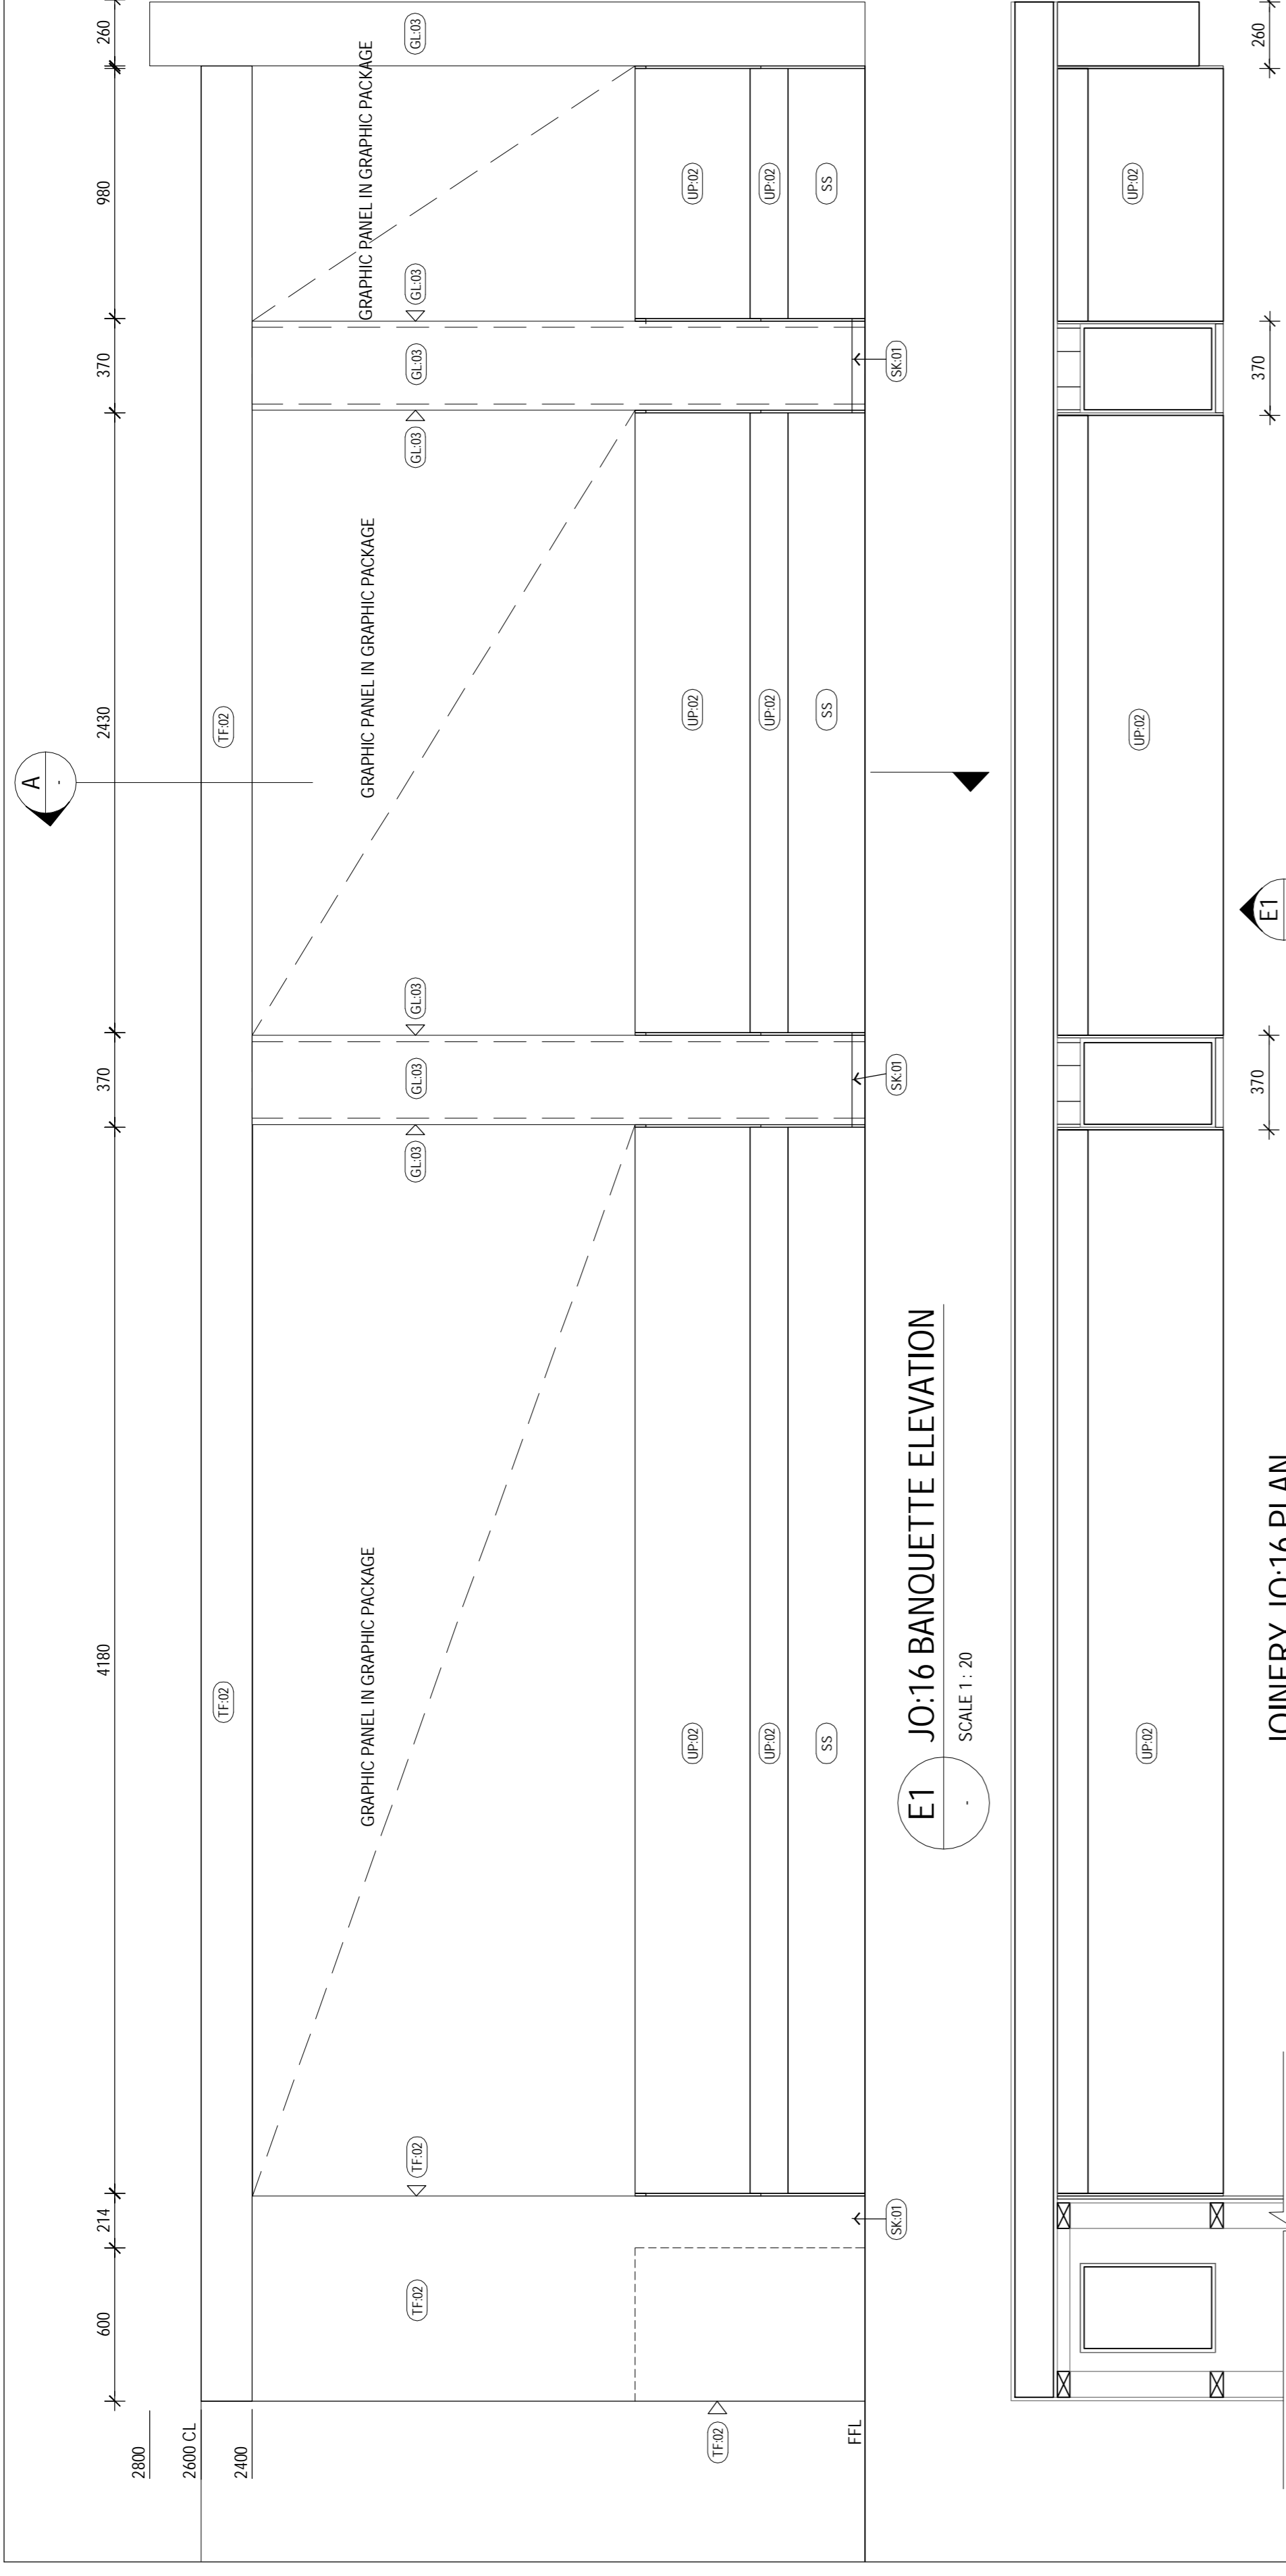

A SECTION JO:06
SCALE 1:20


E1 JO:16 BANQUETTE ELEVATION
SCALE 1:20

JOINERY JO:16 PLAN
SCALE 1:20

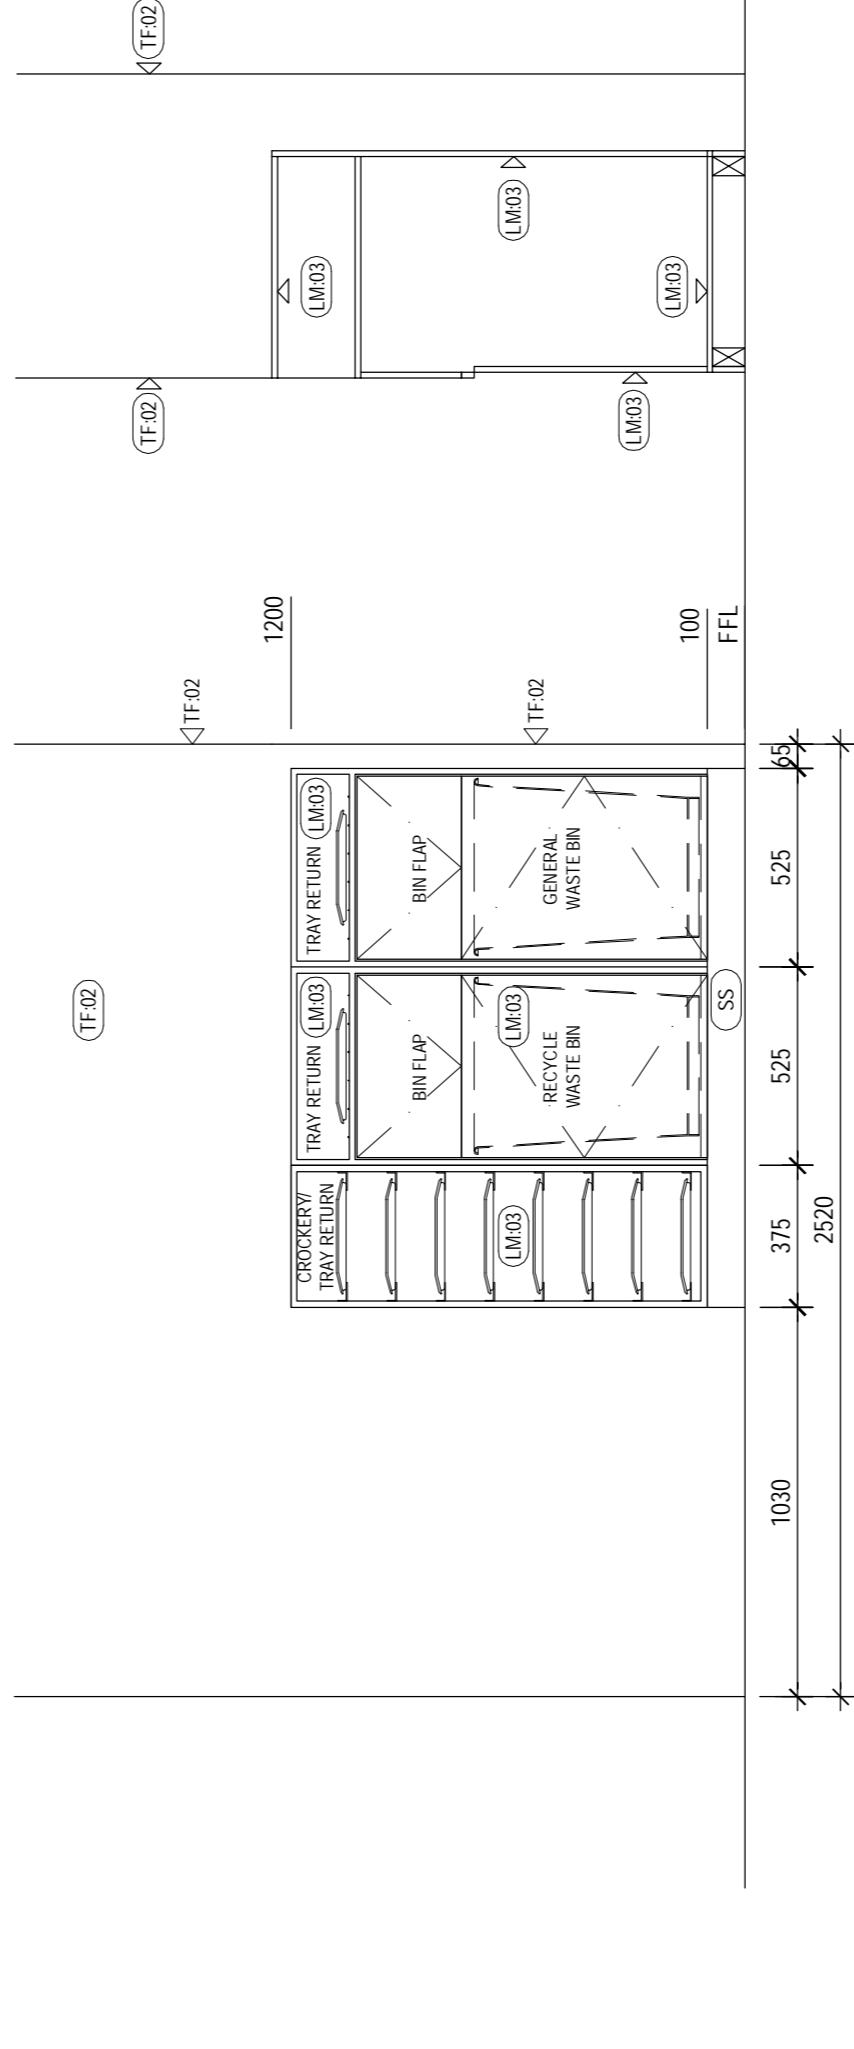


E2 JO:15 SECTION
SCALE 1:20


C JO:15 SECTION
SCALE 1:20

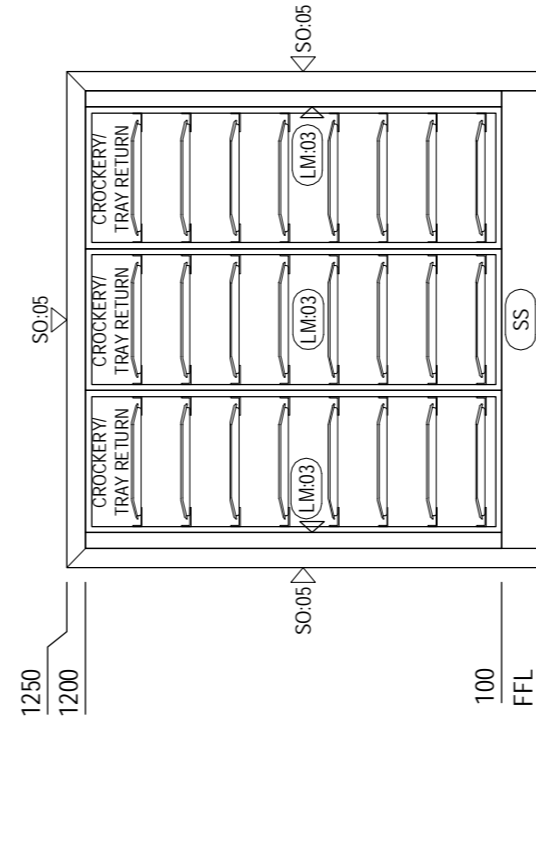

E3 JO:09 ELEVATION
SCALE 1:20

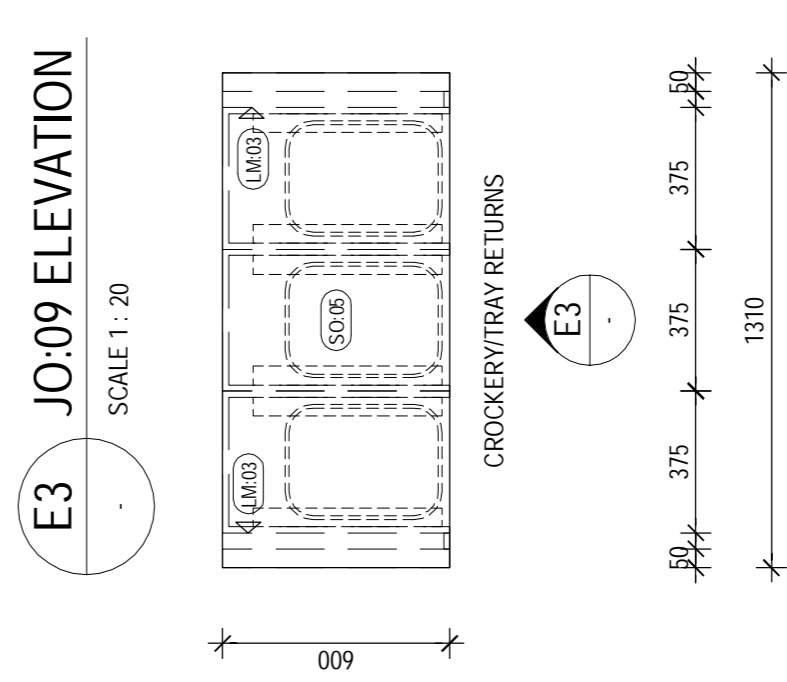

JOINERY JO:09 RETURN UNIT PLAN
SCALE 1:20

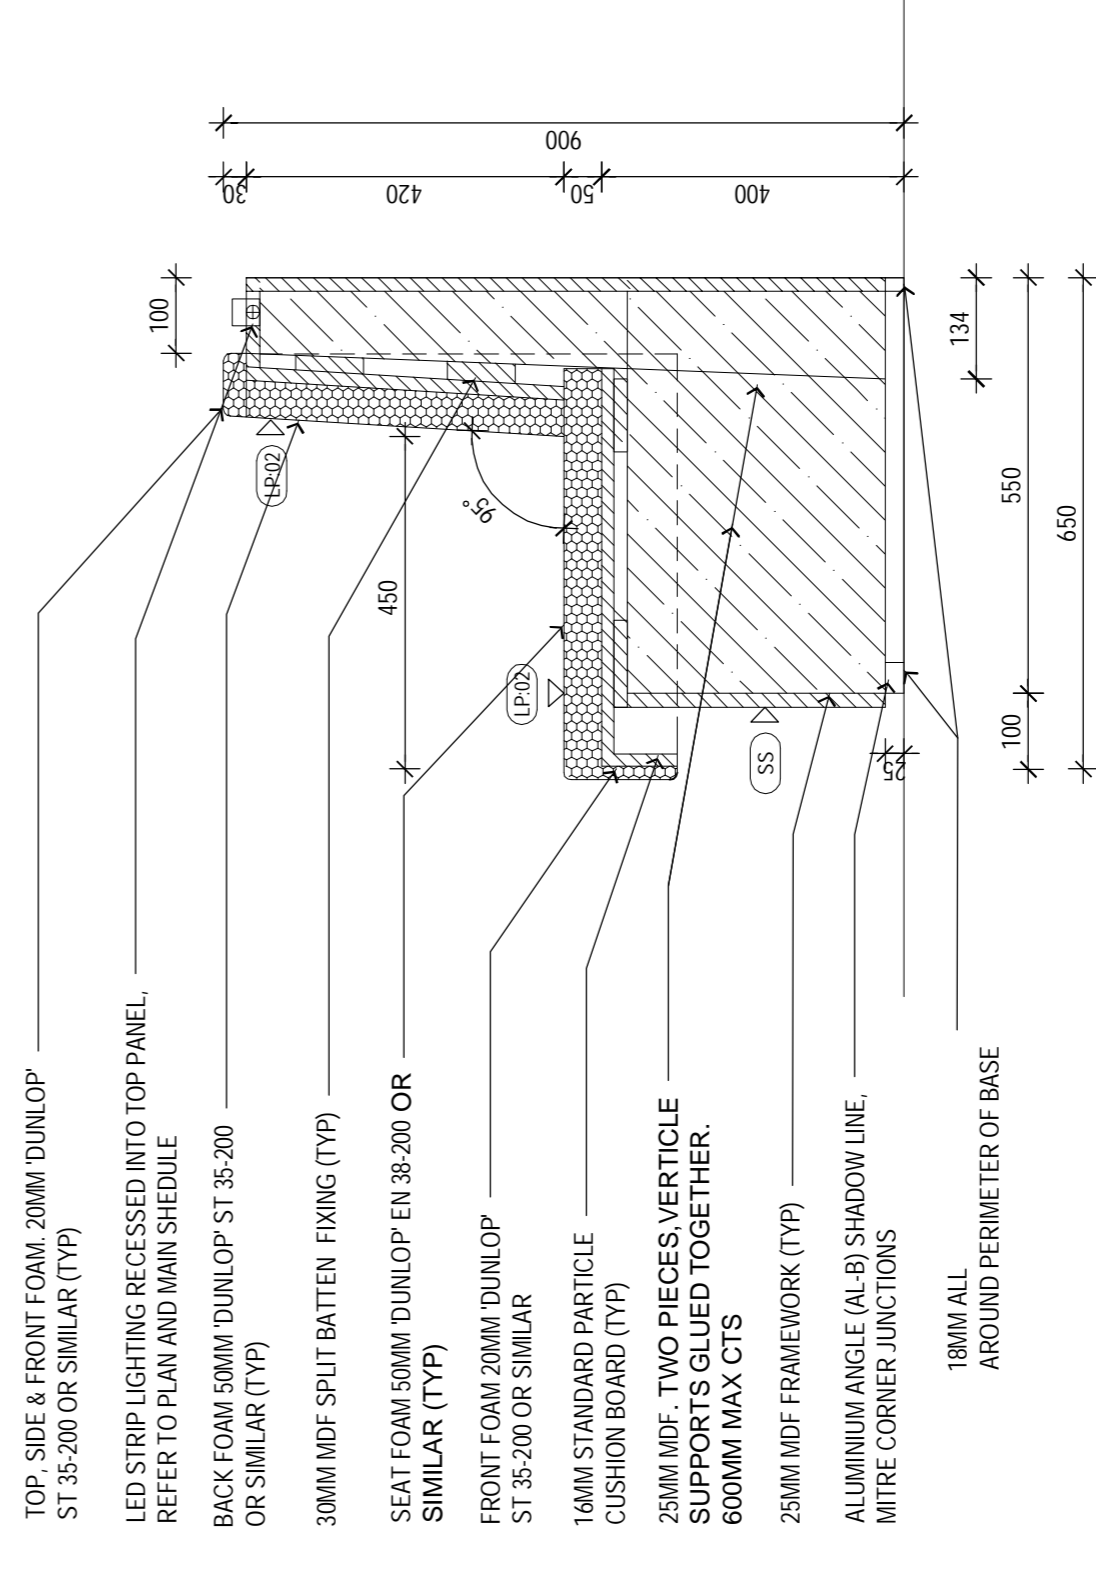

B SECTION JO:06
SCALE 1:10

HỒ SƠ THIẾT KẾ BÀN VÉ THI CÔNG - EXECUTION DESIGN


Client	LIÊN HỢP QUỐC - UNITED NATIONS DEVELOPMENT PROGRAM - UNDP
Project	DỰ ÁN TÒA NHÀ CHUNG LIÊN HỢP QUỐC (2E VẠN PHÚC - 304 KIM MÃ)
Title	CHI TIẾT 5- PHÒNG CAFE- BÀN 2/2
Client/Shop	A1

Chief Design Architect	ANDREW RASZEWSKI
Project Architect	TRAN HAI ANH
Reviewer	
Project Director	21/10/11
Project Architect	BRENDAN SHEEDY
Drawn	LISA BOOKER
Date	05/12/11
Scale	AS SHOWN


GIÁM ĐỐC GHD VIET NAM	
TOBY GARAFILIS	

CLIENTS PEOPLE PERFORMANCE
11/F Alphaland Southgate Tower 2258 Chino Rocas Ave corner EDSA Makati City 1232 Philippines T 63 2 479 5600 F 63 2 479 5601 E email@ghd.com W www.ghd.com

LB	THA	21/10/11		
LB	THA	05/12/11		
Revision	Note	Indicates signatures on original issue of drawing or last revision of drawing	Drawn	Checked/Approved
No	Revision	Note	Drawn	Checked/Approved

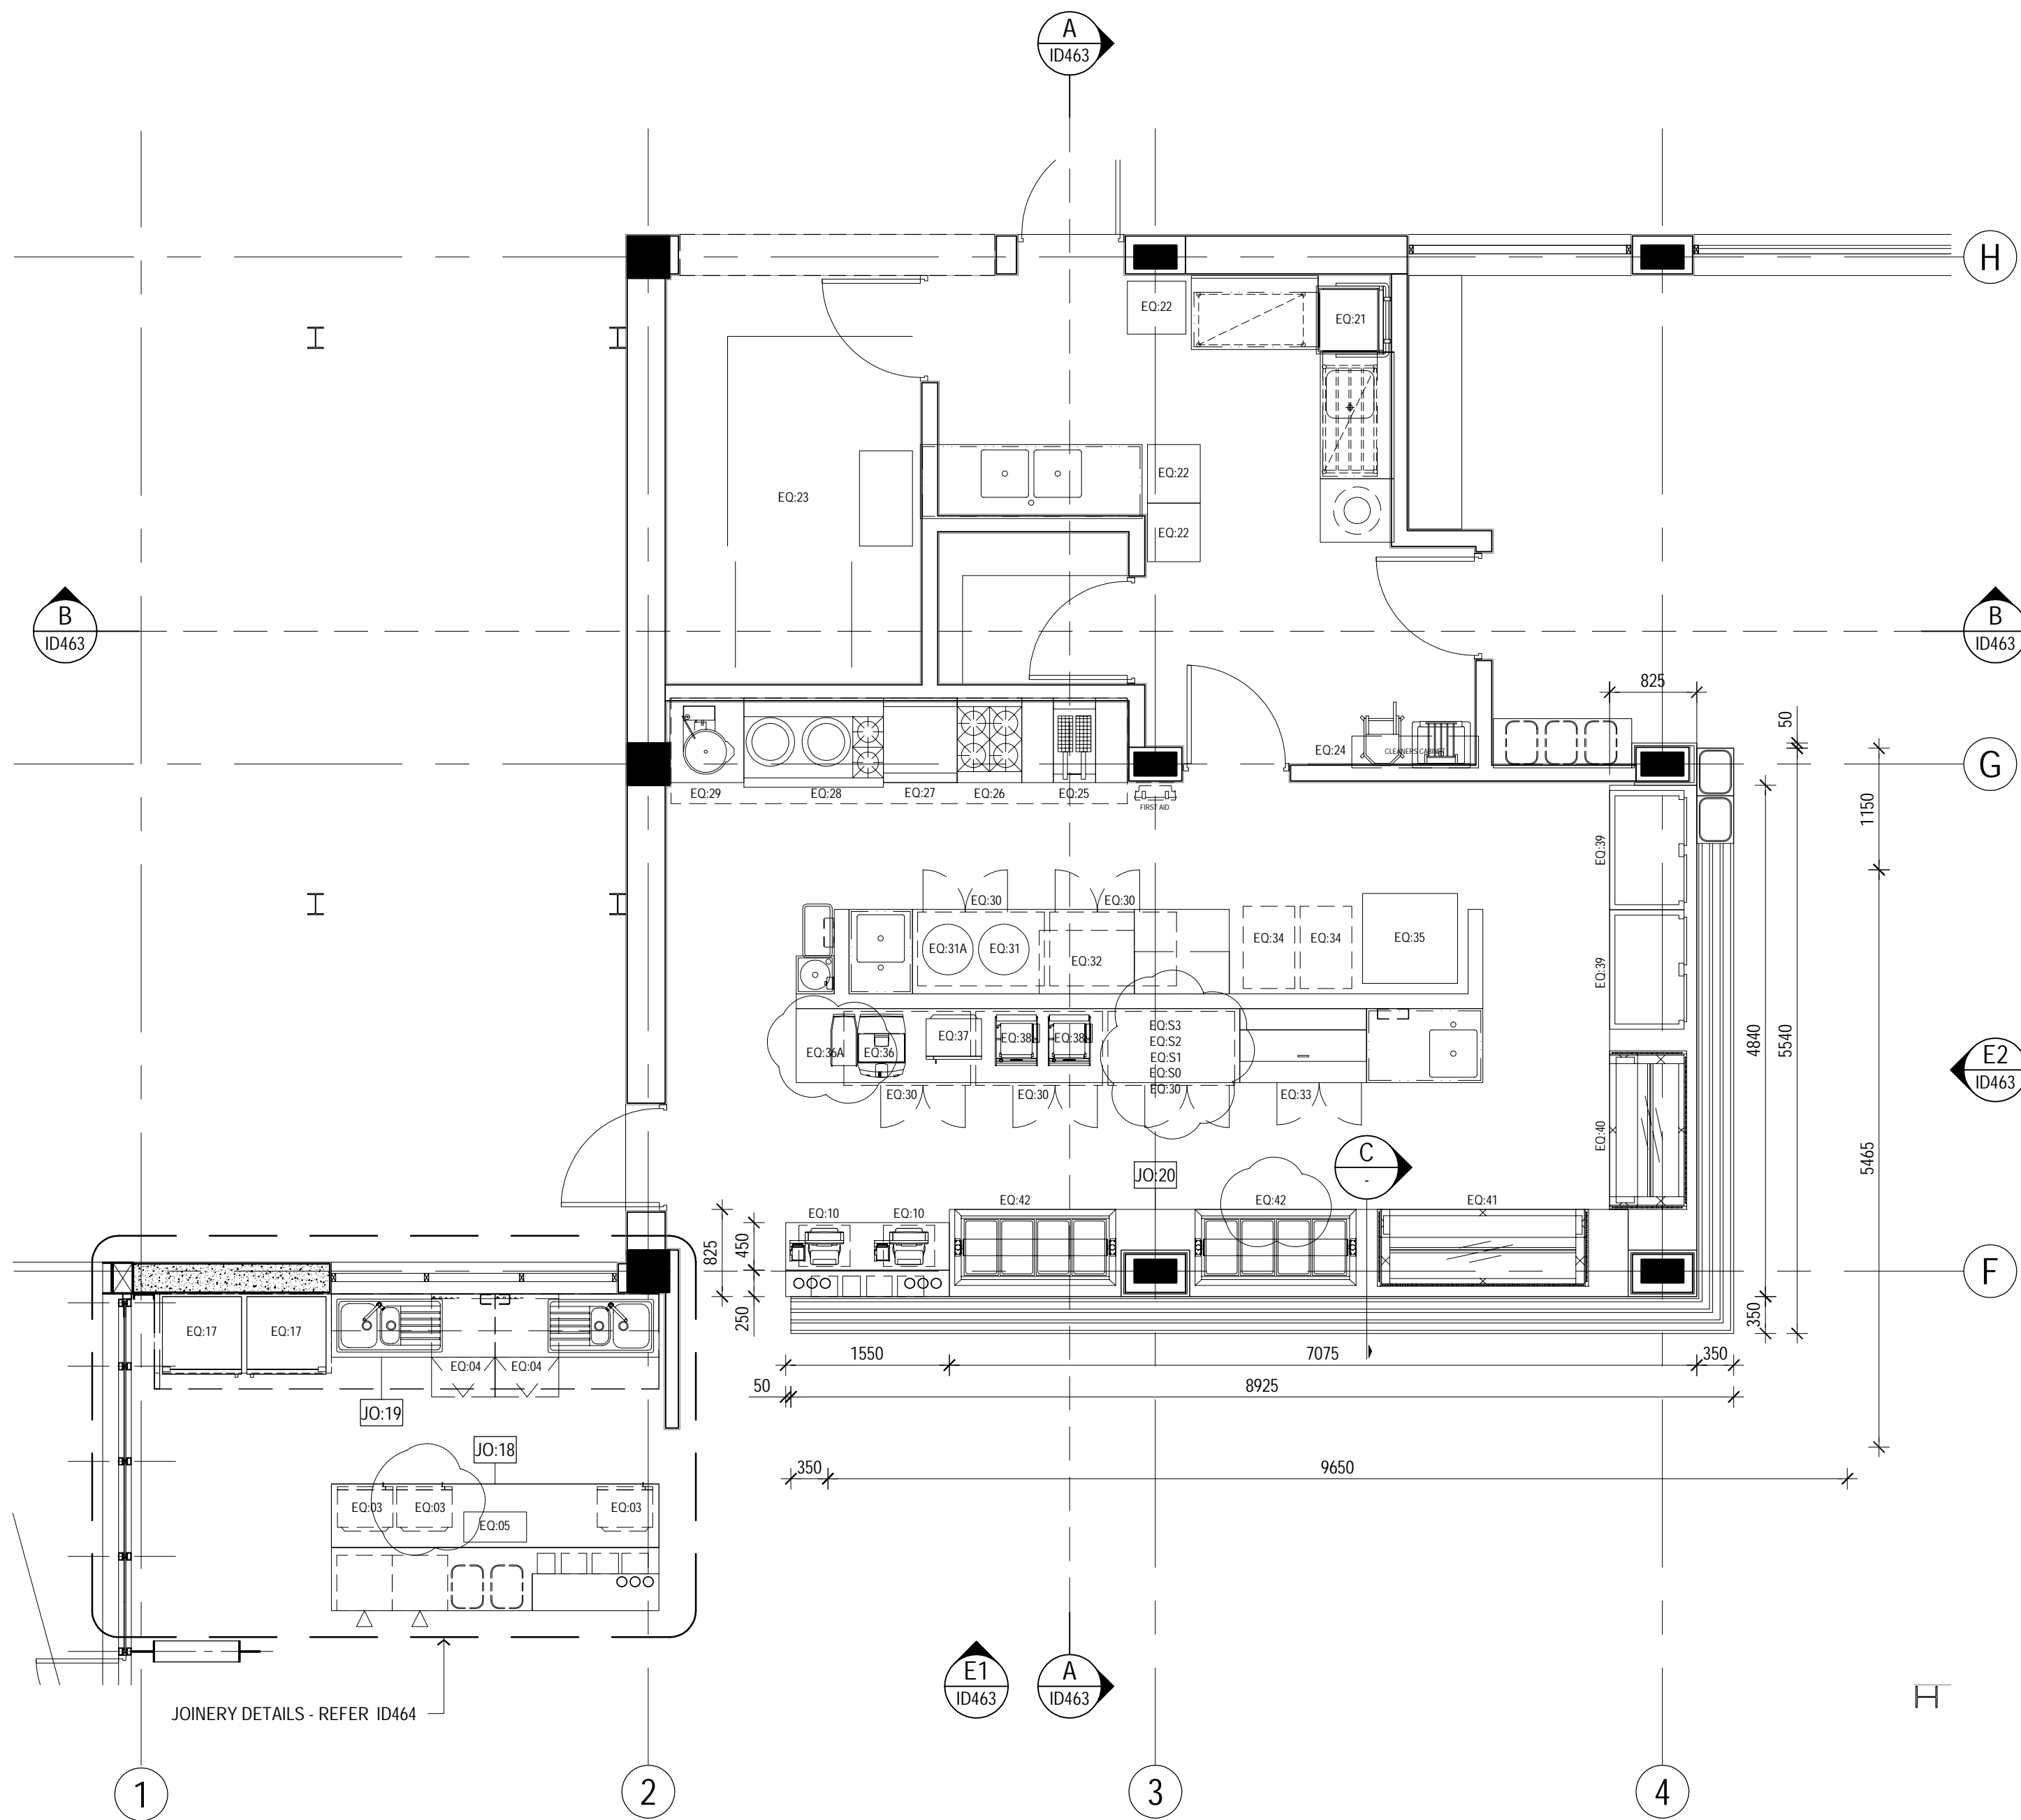

7 CAFE PART PLAN
ID100 SCALE 1 : 25

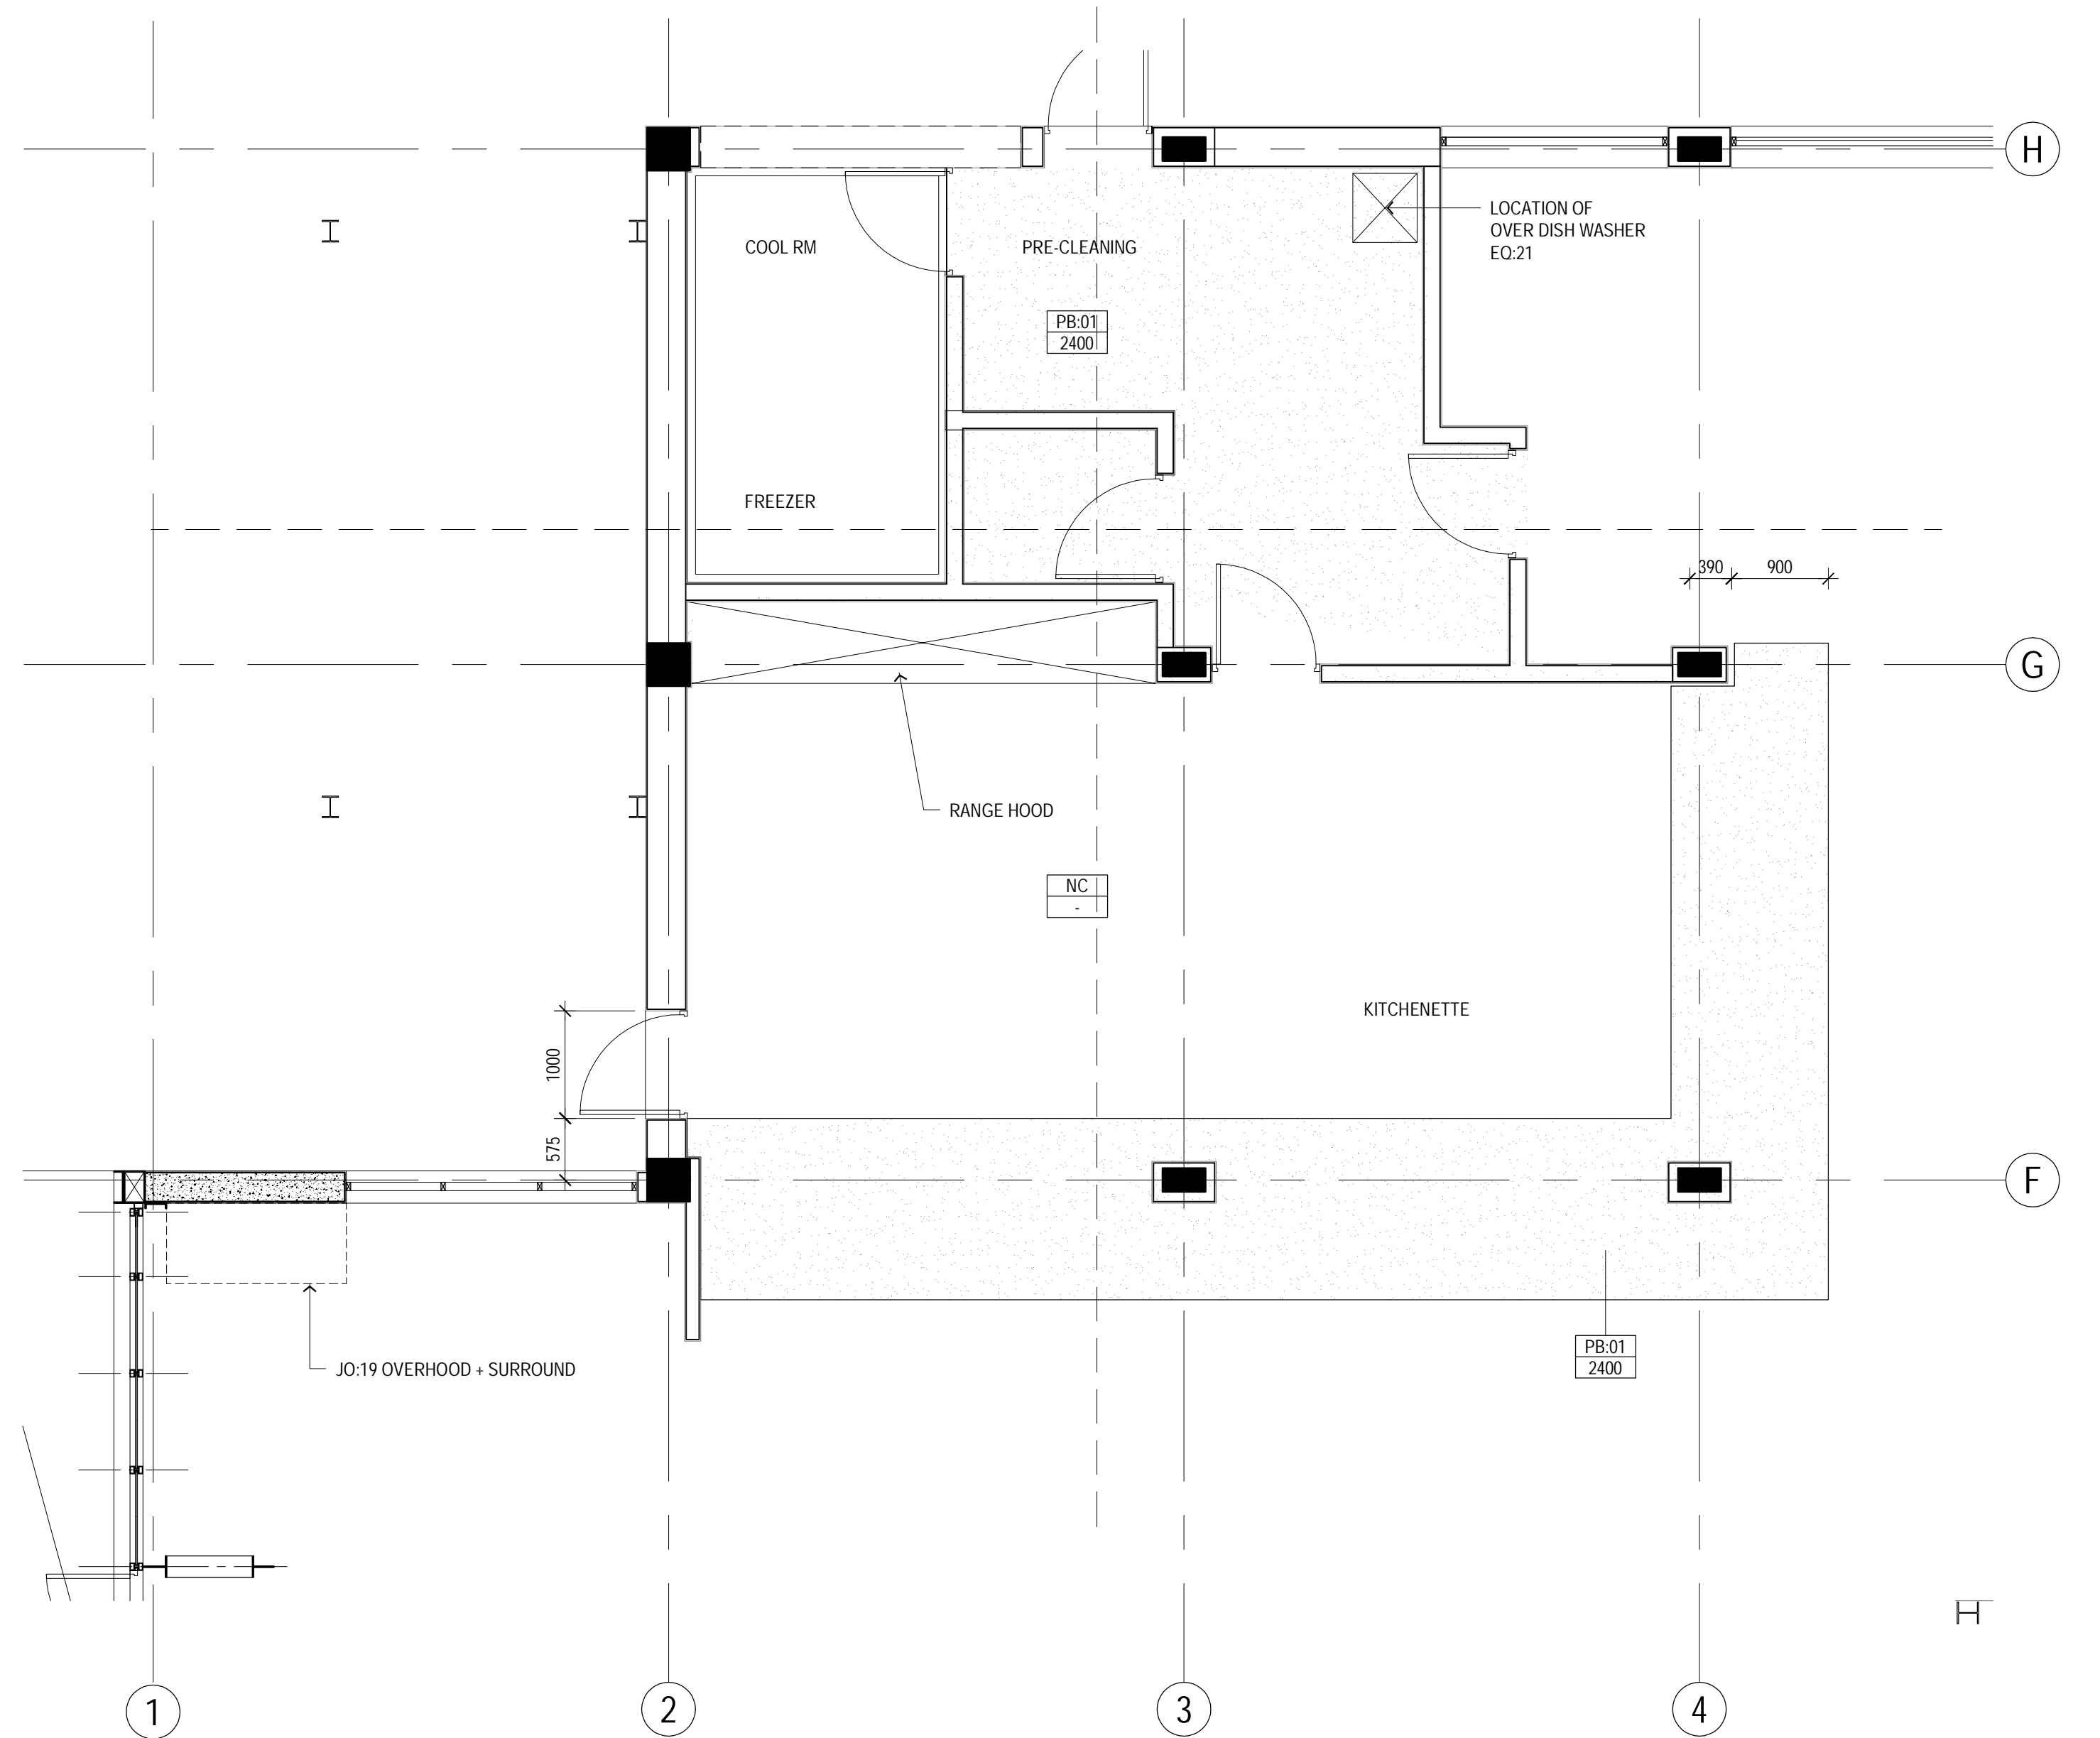

REFLECTED CEILING PLAN
SCALE 1:25

HỒ SƠ THIẾT KẾ BẢN VẼ THI CÔNG - EXECUTION DESIGN

A	EXECUTION DESIGN	LB	THA	21/10/11		
B	ED FINAL ISSUE	LB	THA	05/12/11		
C	FFE UPDATE	TA	OP	13/06/13		
No	Revision	Note: * indicates signatures on original issue of drawing or last revision of drawing	Drawn	Checked	Approved	Date

GHD CLIENTS | PEOPLE | PERFORMANCE

11/F Alphaland Southgate Tower 2258 Chino Roces Ave corner EDSA
Makati City 1232 Philippines
T 63 2 479 5600 F 63 2 479 5601
E mnlmail@ghd.com W www.ghd.com

GIÁM ĐỐC GHD VIỆT NAM

[Signature]

TOBY GARAFILLIS

Project Director	CHRIS LLOYD	Chief Design Architect	ANDREW RASZEWSKI
Project Architect	BRENDAN SHEEDY	Reviewer	TRAN HAI ANH
Drawn	LISA BOOKER		
Date	05/12/11		
Scale	1:25		

Client: **LIÊN HỢP QUỐC - UNITED NATIONS DEVELOPMENT PROGRAM - UNDP**







Project: **DỰ ÁN TÒA NHÀ CHUNG LIÊN HỢP QUỐC (2E VẠN PHÚC - 304 KIM MÃ)**

Title: **CHI TIẾT 7- PHÒNG CAFE- BÀN 1/3**
CAFE PART PLAN - DETAIL 7 - SHEET 1 OF 3

Original Size: **A1** Drawing No: **63-11049-ID462**

Rev: **C**

This Drawing must not be used for construction unless signed as Approved

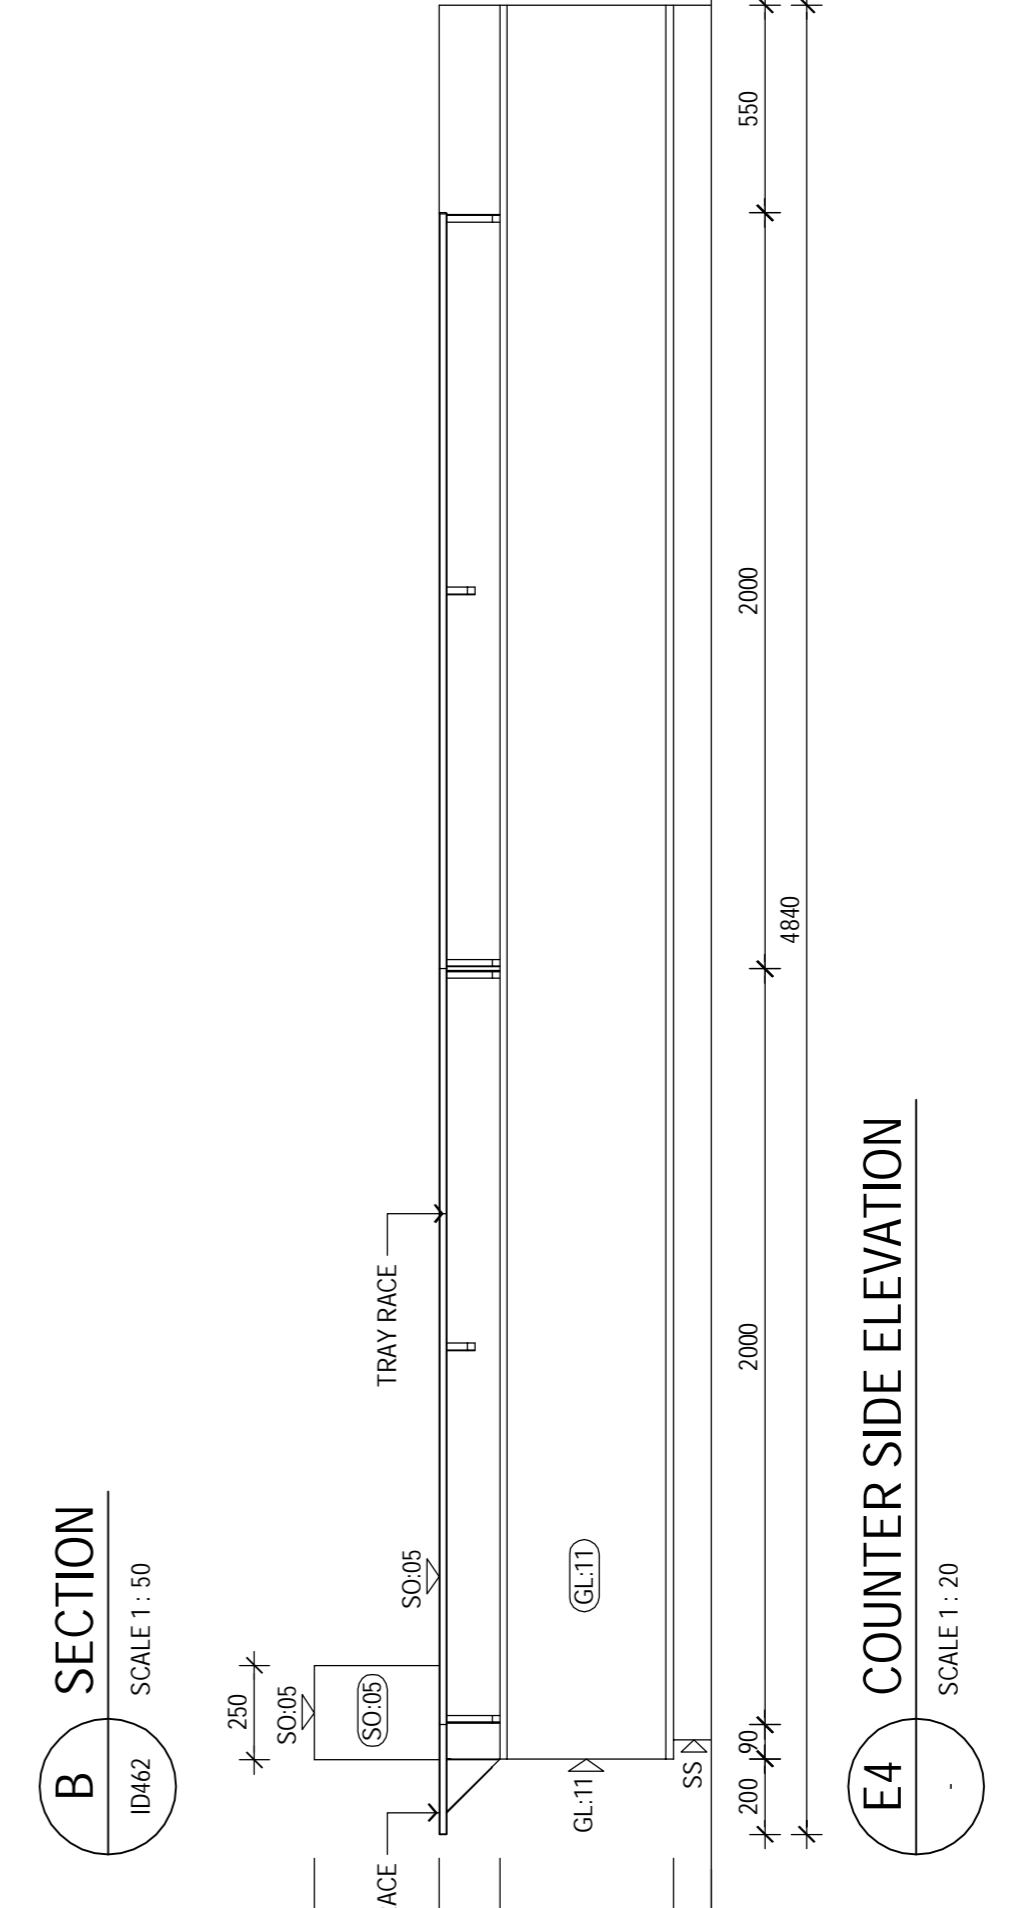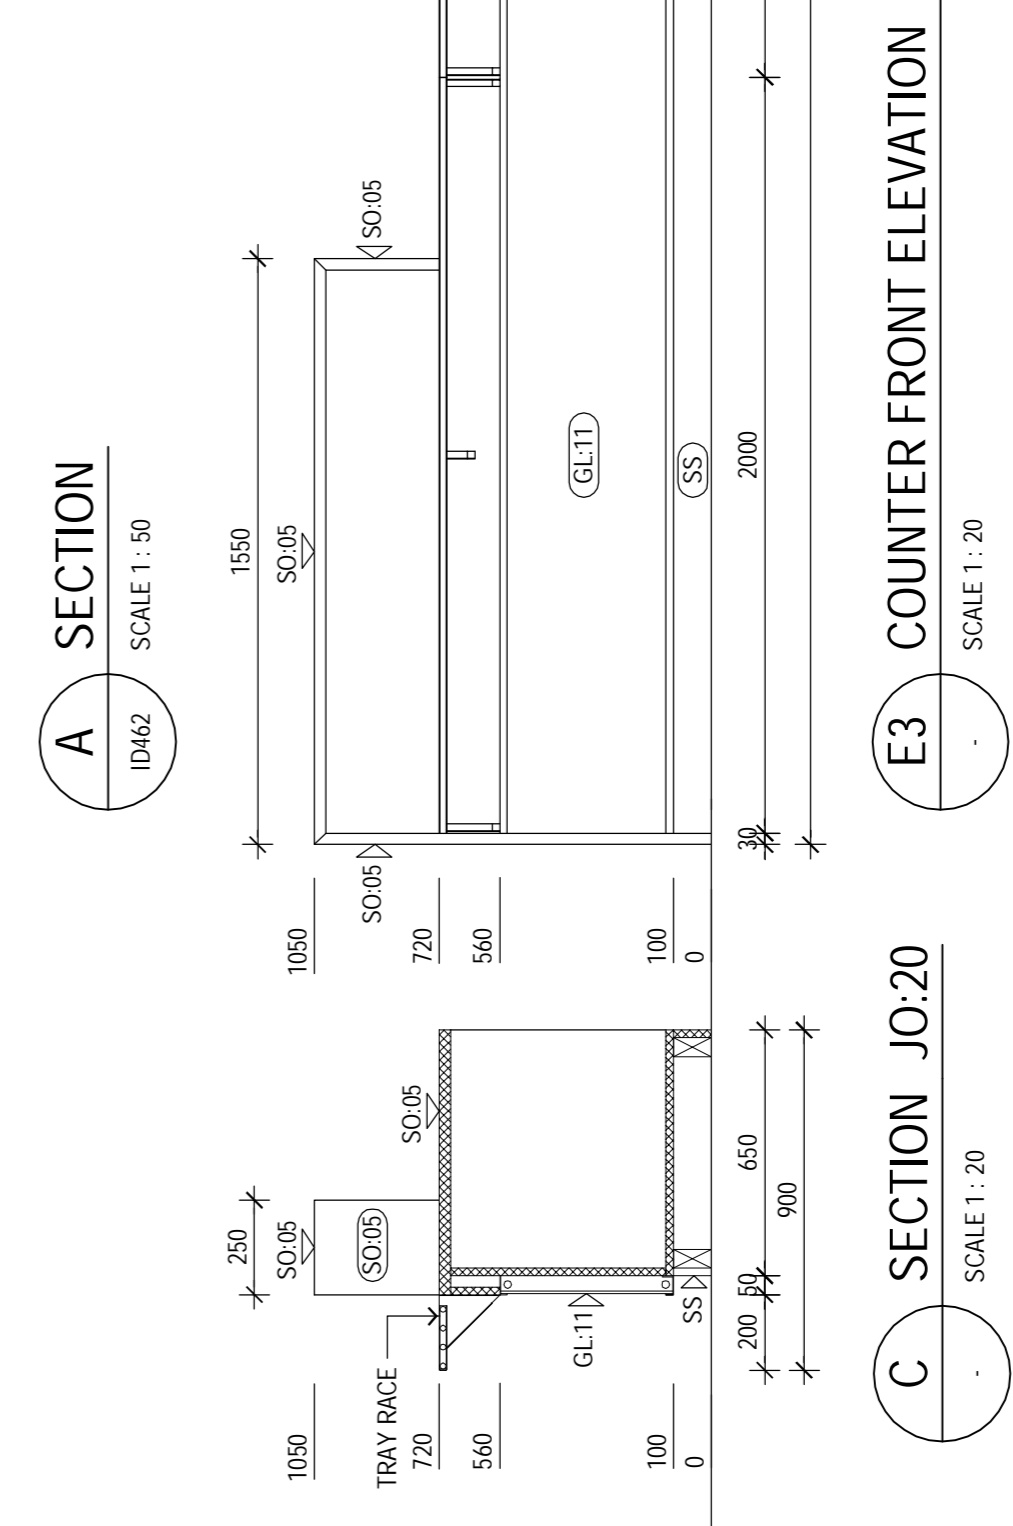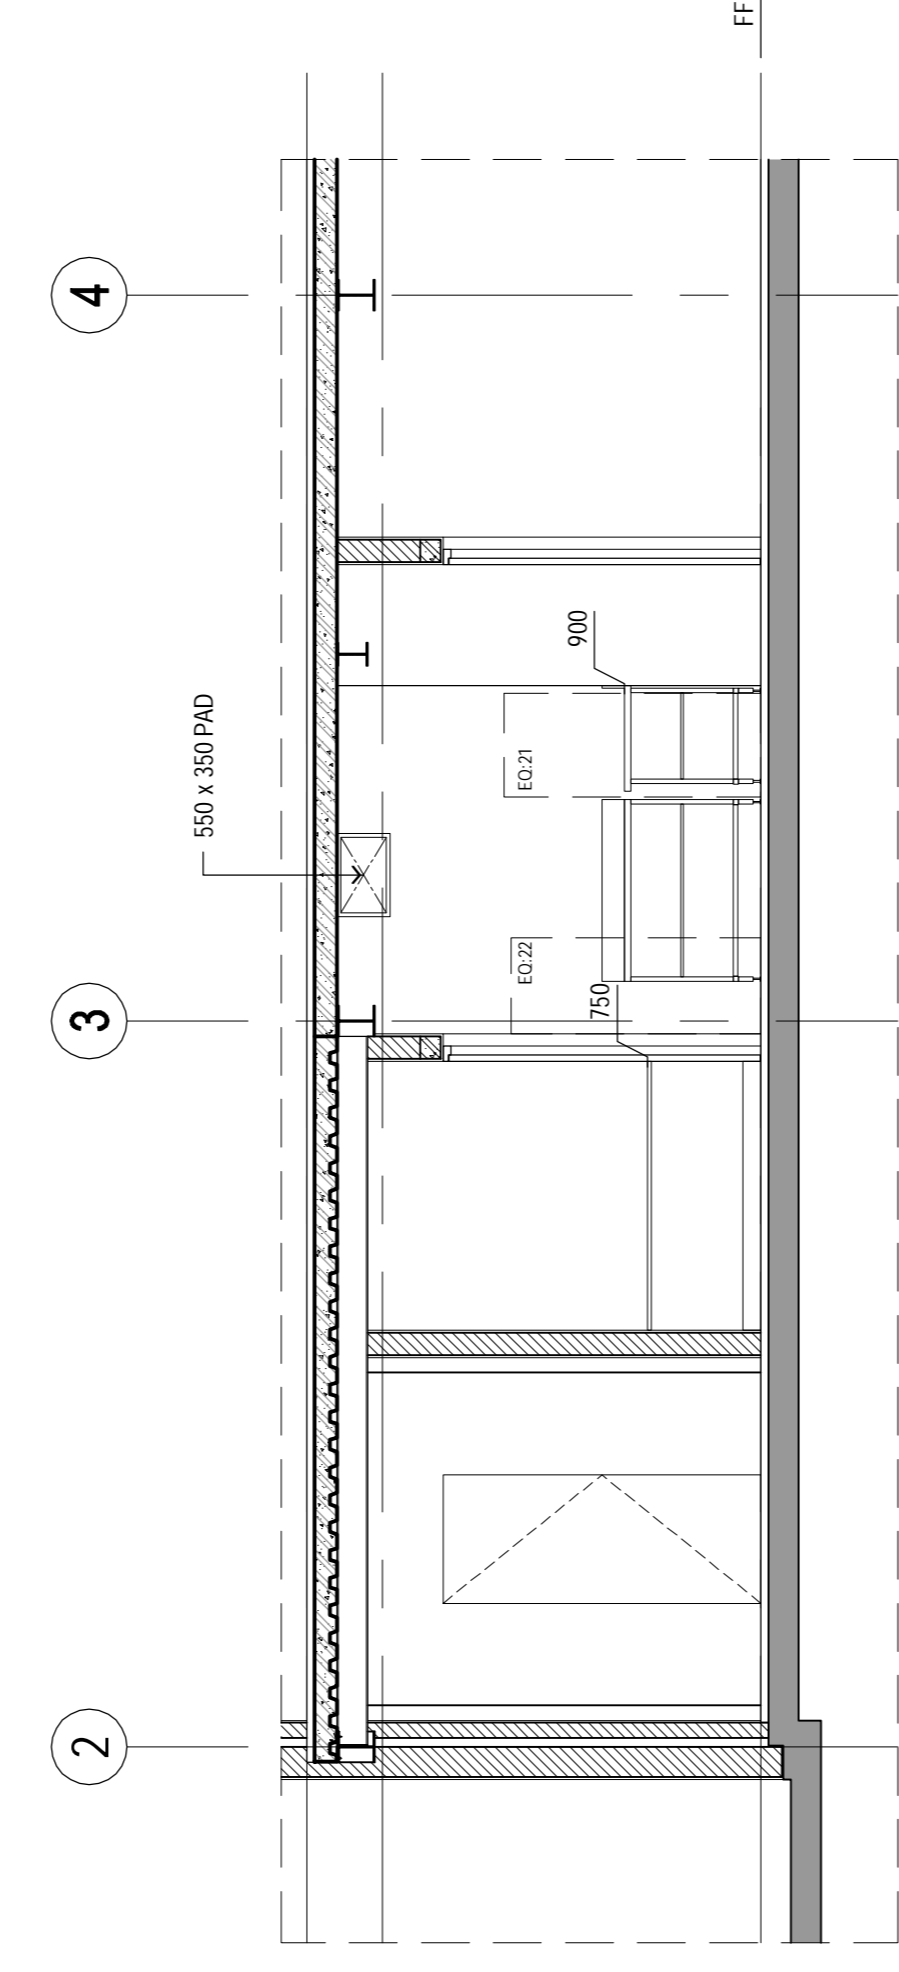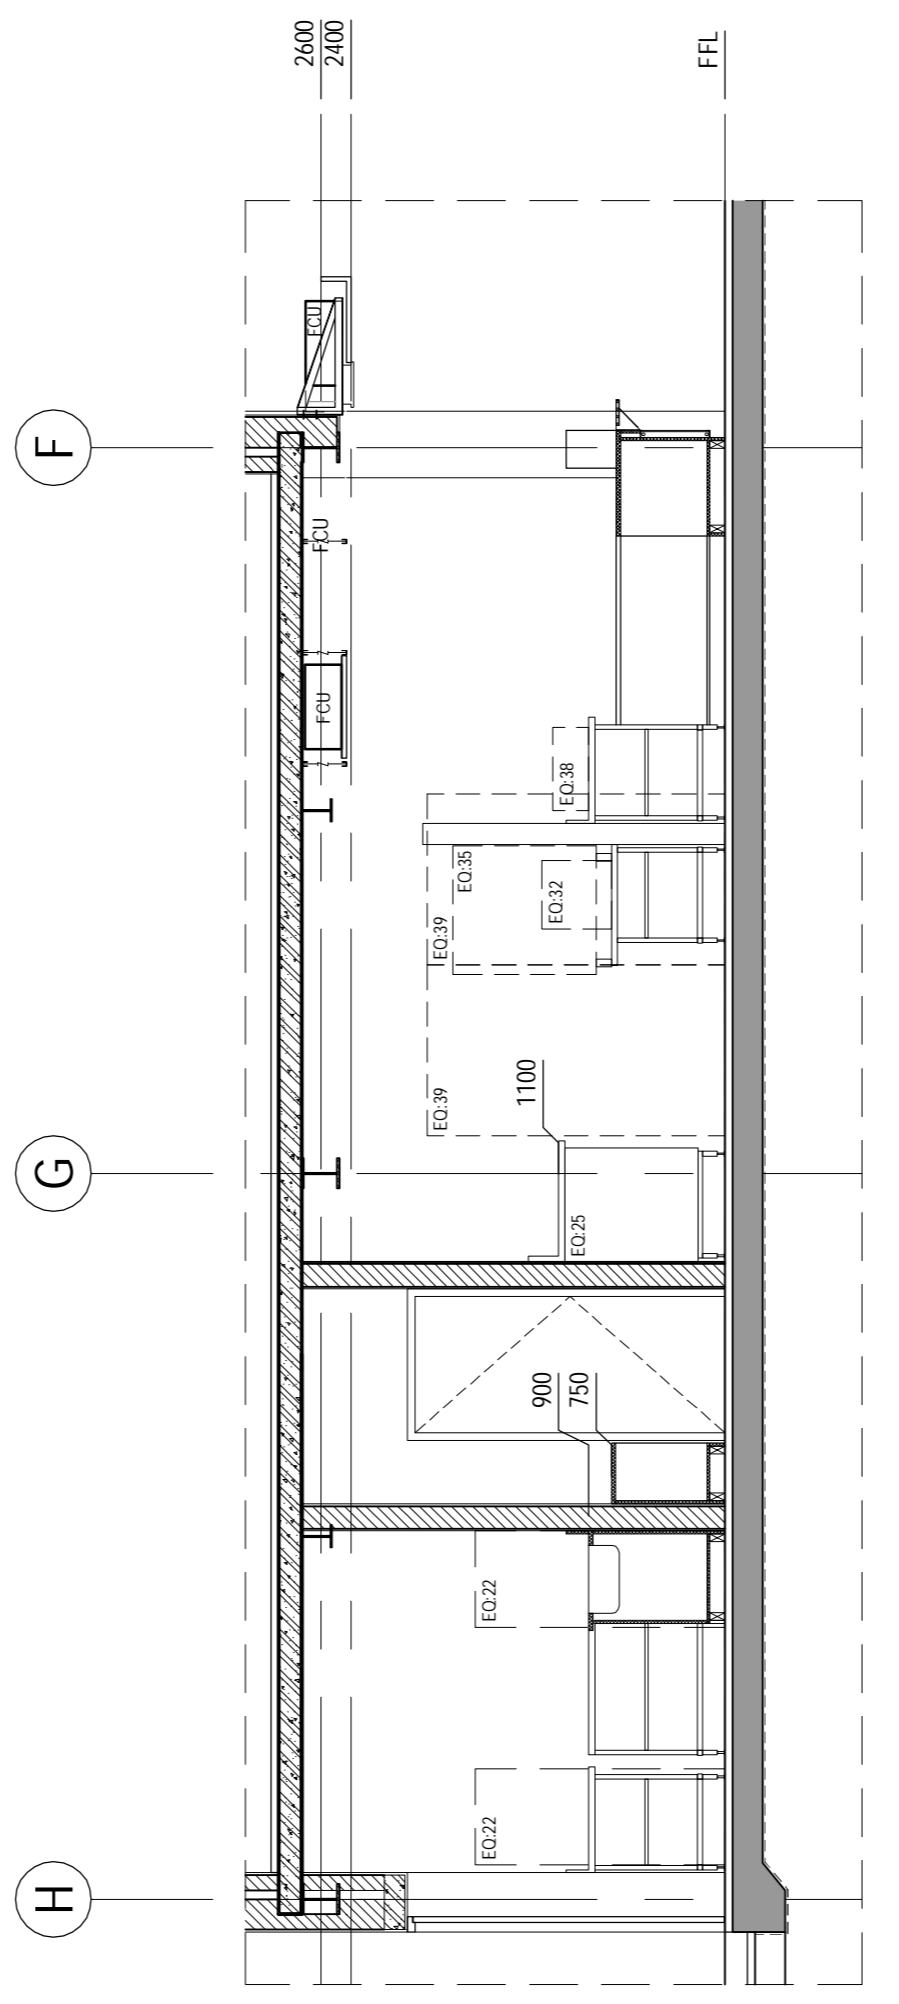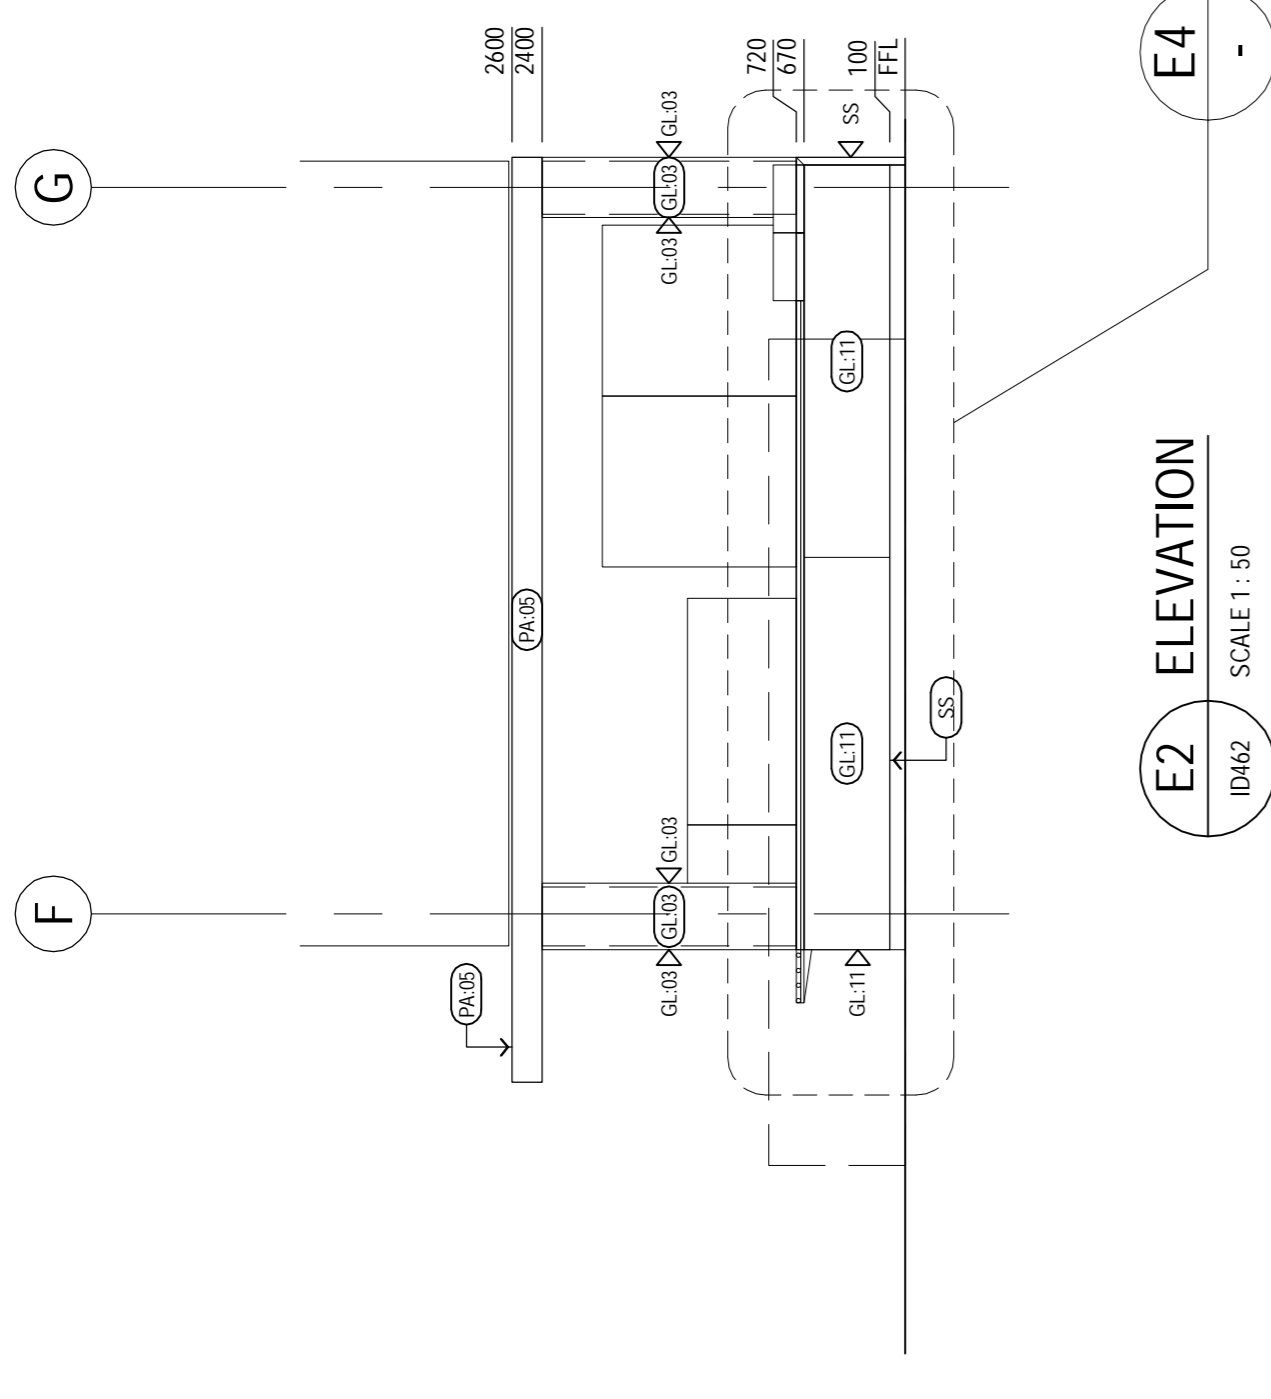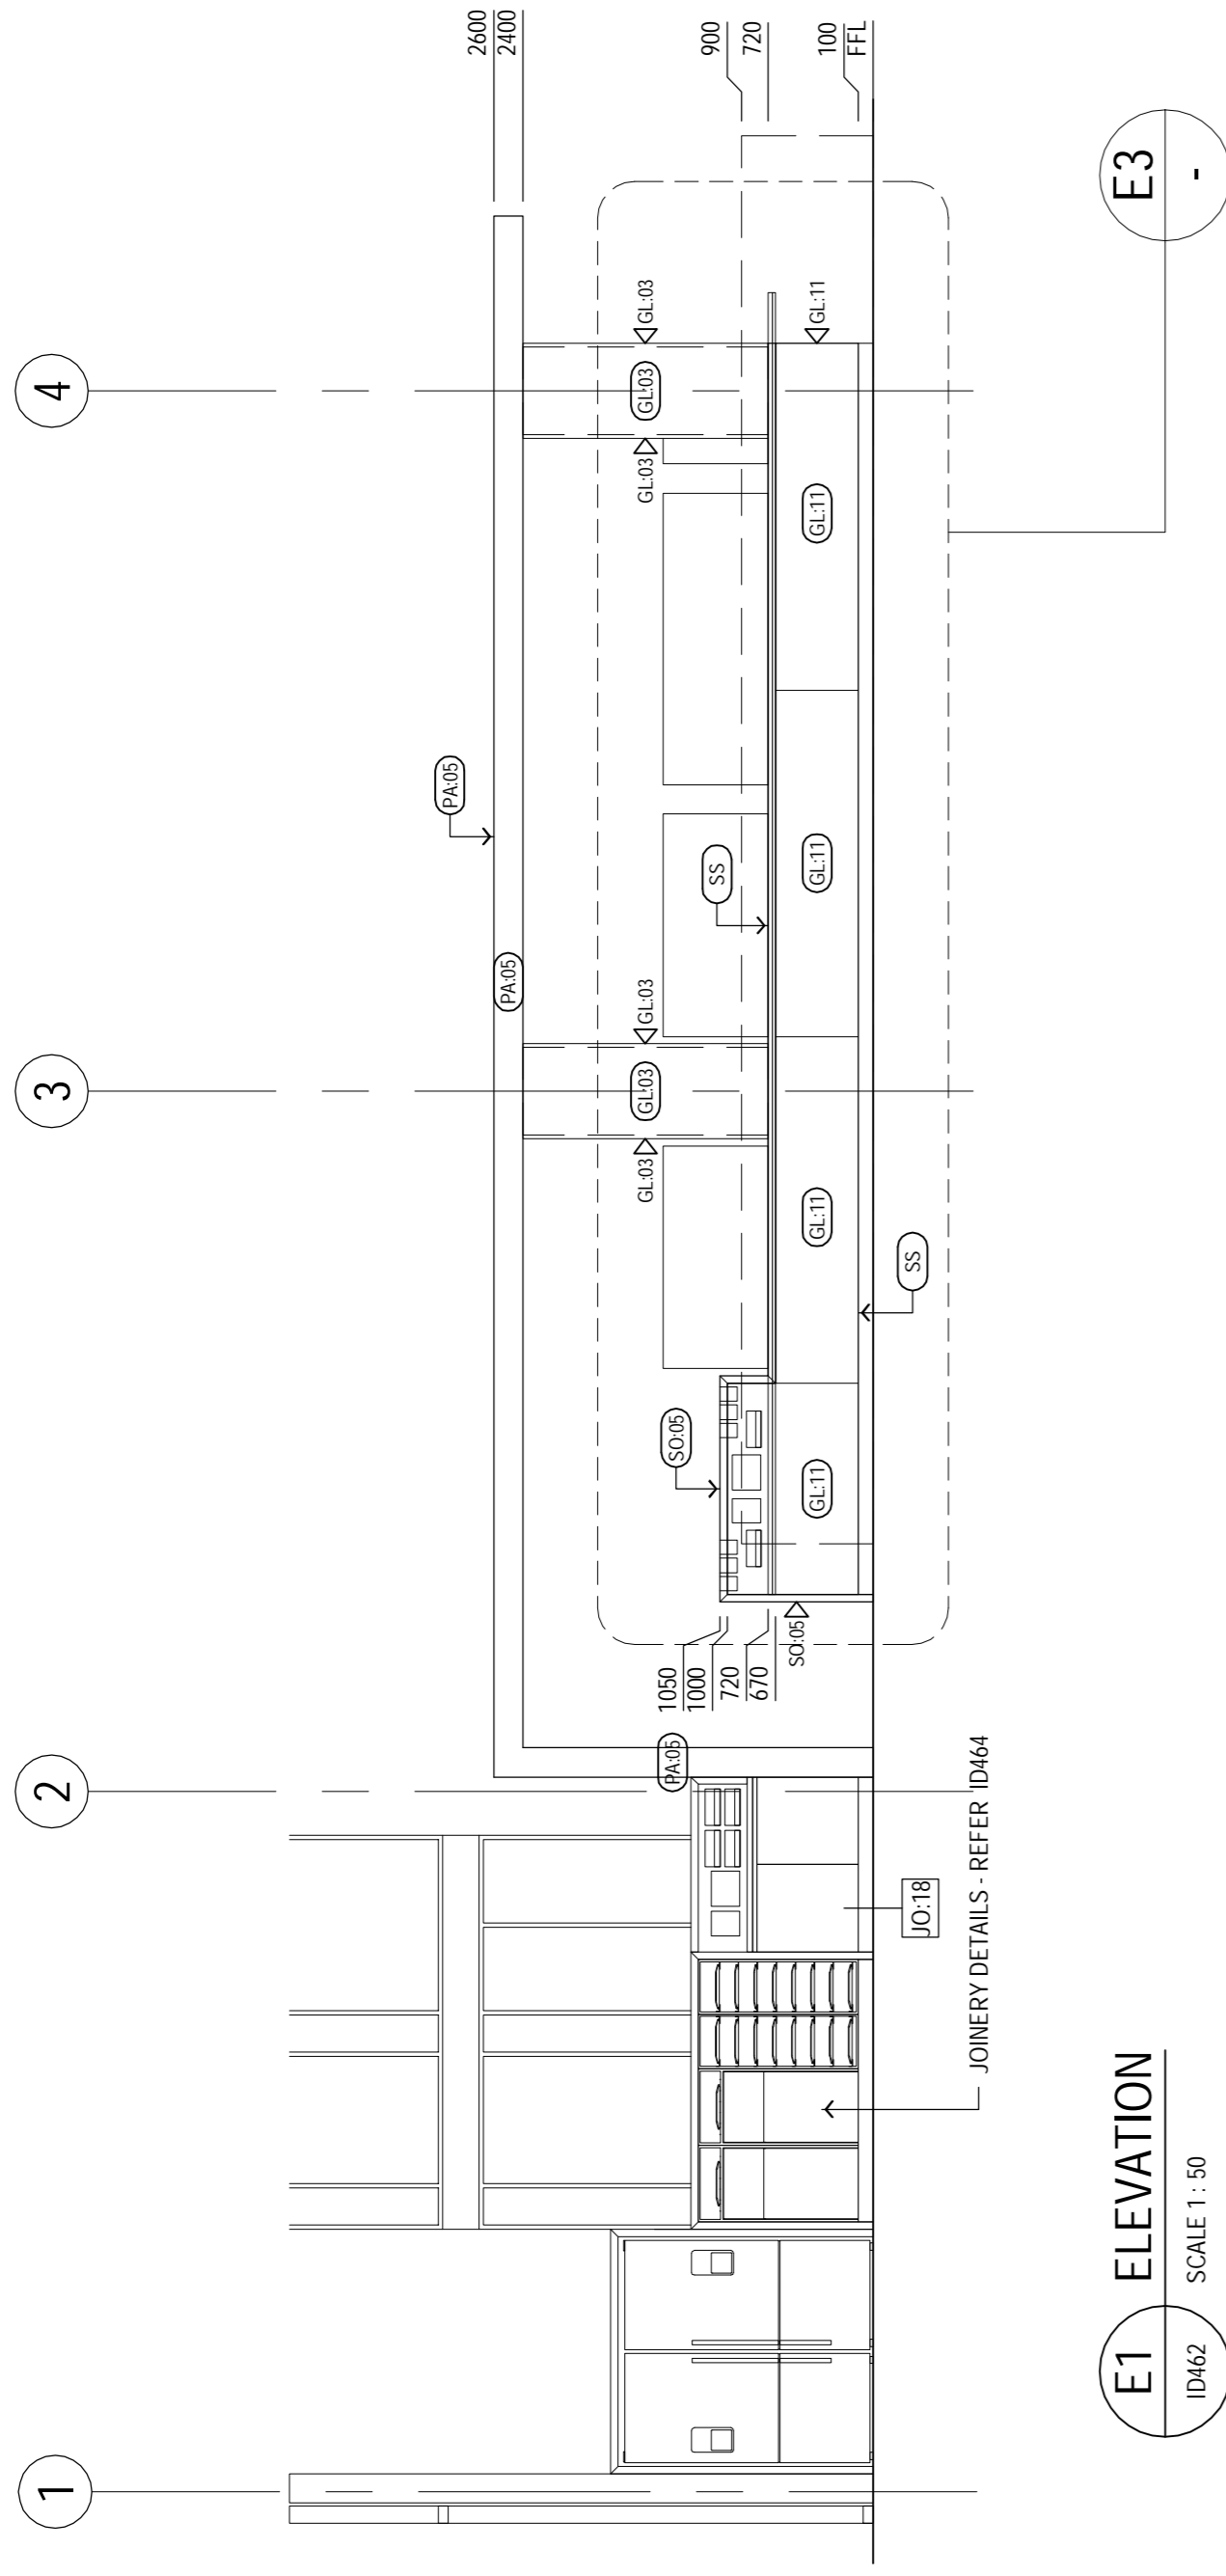

A EXECUTION DESIGN		L B		THA		21/10/11		GIÁM ĐỐC GHD/VIỆT NAM		Project Director		Chief Design Architect		Client	
B ED FINAL ISSUE		LB		THA		05/12/11		GIÁM ĐỐC GHD/VIỆT NAM		CHRIS LLOYD		ANDREW RASZEWSKI		LIÊN HỢP QUỐC - UNITED NATIONS DEVELOPMENT PROGRAM - UNDP	
No		Revision		Date		Date		TOBY GARAFILIS		LISA BOOKER		TRAN HAI ANH		DỰ ÁN TÒA NHÀ CHUNG LIÊN HỢP QUỐC (2E VẠN PHÚC - 304 KIM MÃ)	
Note: - indicates signatures on original issue of drawing or last revision of drawing		Drawn		Checked/ Approved		Date		AS SHOWN		AS SHOWN		AS SHOWN		CHI TIẾT 7- PHÒNG CAFE- BÀN 2/3	
Note: - indicates signatures on original issue of drawing or last revision of drawing		Drawn		Checked/ Approved		Date		AS SHOWN		AS SHOWN		AS SHOWN		CAFE PART PLAN - DETAIL 7 - SHEET 2 OF 3	
Plot Date: 2 December 2011 - 2:23 PM		G:\6311049\CADD\Drawings\63-11049-ID462_Ground Floor Cafe Detail 7 - Sheet 1 of 2.dwg		Client File No:		G:\6311049\CADD\Drawings\63-11049-ID462_Ground Floor Cafe Detail 7 - Sheet 1 of 2.dwg		Drawing No:		63-11049-ID463		Rev:		B	

HỒ SƠ THIẾT KẾ BẢN VẼ THI CÔNG - EXECUTION DESIGN

LIÊN HỢP QUỐC - UNITED NATIONS DEVELOPMENT PROGRAM - UNDP
DỰ ÁN TÒA NHÀ CHUNG LIÊN HỢP QUỐC (2E VẠN PHÚC - 304 KIM MÃ)
CHI TIẾT 7- PHÒNG CAFE- BÀN 2/3
CAFE PART PLAN - DETAIL 7 - SHEET 2 OF 3

